




 




 
 



 

 
1 **GROUND FLOOR PLAN**
A-01 SCALE 1:100 mts.

 <p>Republic of the Philippines DEPARTMENT OF HEALTH Center for Health Development IV-A CALABARZON DOH-4A, QMMC Compound, Project 4, Quezon City</p> 	PROJECT TITLE: REPAIR/ RENOVATION/ EXTENSION/ CONSTRUCTION/ UPGRADING/ IMPROVEMENT OF HEALTH FACILITIES FOR DON MANUEL LOPEZ MEMORIAL DISTRICT HOSPITAL LOCATION : BALAYAN, BATANGAS	PREPARED BY: JOHN LERY M. PALINES, CE ENGINEER II	CHECKED BY: ERIC JOSE R. MIRAS, RLA ARCHITECT III	REVIEWED BY: RONALD L. DOROTEO, CE ENGINEER III / PMU HEAD	APPROVED BY: EDUARDO C. JANAIRÓ, MD, MPH, CESO III DIRECTOR IV RACEL G. CARREON, MM CHIEF ADMINISTRATIVE OFFICER PAULA PAZ M. SYDIONGCO, MD MPH, CESO IV ASSISTANT REGIONAL DIRECTOR	SHEET CONTENT: GROUND FLOOR PLAN	SHEET NUMBER: A-01

GENERAL NOTES :

1. ALL WORK AND INSTALLATION SHALL BE DONE UNDER A DIRECT SUPERVISION OF A LICENSED ELECTRICAL ENGINEER. THE CONTRACTOR SHALL COORDINATE AND CONSTANTLY UPDATE ITS RELATED WORKS WITH OTHER TRADE CONTRACTORS. WORKS SHALL BE EXECUTED IN THE MOST THOROUGH PROMPT AND WORKMAN LIKE MANNER BY USING STANDARD METHODS WITH GOOD ENGINEERING PRACTICE.
2. POWER SERVICE SHALL BE 230 VOLTS, THREE-PHASE, 60 HERTZ. TAP TO THE EXISTING POWER SOURCE PROVIDED IN THE AREA & AUXILIARIES SUPPLY SOURCE SUCH AS TELEPHONE, CABLE-TV, PAGING & MASS SIGNAL LINE SHALL BE TAP TO EXISTING LINE WITH-IN THE AREA. (COORDINATE WITH MAINTANANCE PERSONNEL)
3. THE PLAN AND SPECIFICATION ARE INTENDED TO PRESENT A GENERAL LAYOUT, OUTLINE AND DESCRIPTION OF THE PROJECT AND NOT NECESSARY INDICATE, DESCRIBED ACTUAL LOCATION LEVELS AND DISTANCES OF EQUIPMENT. THE CONTRACTOR IS HEREBY REQUIRED TO MAKE THE NECESSARY ADJUSTMENT THAT WILL BE SUITABLE TO THE ACTUAL FIELD CONDITION. POWER AND AUXILIARY CIRCUIT ARE ALSO PROVIDED WITH EMPTY CONDUIT INTERCONNECTION FOR DESIGN FLEXIBILITY INTENDED FOR POSSIBLE RELOCATION OF ITS EQUIPMENT.
4. ALL ELECTRICAL INSTALLATION SHALL BE PROPERLY GROUNDED IN ACCORDANCE WITH THE PHILIPPINE ELECTRICAL CODE. (GROUND WIRE SHALL BE COLOR CODED – GREEN)
5. MINIMUM SIZE OF CONDUCTOR AND CONDUIT SHALL BE 2.0mmø for SOLID OR 3.5mm² STRANDED (AWG #12) THHN /THWN COPPER WIRE AND 15mmø FOR METAL OR 20mmø FOR PVC CONDUIT, RESPECTIVELY UNLESS OTHERWISE INDICATED IN THE PLAN OR AS RECOMMENDED BY THE DESIGNER FOR ITS INTENDED USE. WIRING INSTALLATION SHALL BE STRICTLY COLOR CODED.
6. METHOD OF CONDUIT INSTALLATION SHALL BE DONE AS FOLLOWS :
- a. PVC PIPE (SCH.-40) ORANGE LIGHTING POWER AND AUXILARY CIRCUITS EMBEDDED IN CONCRETE WALL/FLOOR.
- b. EMT / RSC / IMC PIPE LIGHTING, POWER, FIRE ALARM CIRCUITS ABOVE CEILING DRYWALL OR EXPOSED
- c. FLEXIBLE PVC / METAL CONDUIT LIGHTING CIRCUITS ABOVE CEILING FROM BOX TO LT. FIXTURE
- d. OTHERS – AS RECOMMENDED BY ELECTRICAL ENGINEER AND APPROVED BY CONSULTANT FOR INTENDED USE.
7. MOUNTING HEIGHT FOR WIRING DEVICES, PANELS & BOXES:
- a. CONVENIENCE OUTLETS & AUXILIARY OUTLETS 0.30M ABOVE FLOOR FINISHED OR COUNTER TOP AT CENTER.
- b. CONVENIENCE OUTLETS & AUXILIARY OUTLETS 0.50M ABOVE FLOOR FINISHED AT CENTER. (OUTDOOR AREA)
- b. LIGHTING SWITCHES, C.B. PANELBOARDS 1.40M ABOVE FLOOR FINISHED AT CENTER
- c. CIRCUIT BREAKERS, PANELBOARDS & AUX. BOXES 1.50M ABOVE FLOOR FINISHED AT CENTER
- d. OTHERS – AS RECOMMENDED BY ELECTRICAL ENGINEER AND APPROVED BY CONSULTANT FOR INTENDED USE.
8. WALL SWITCH SHALL BE TUMBLER-TYPE, RATED 10A, 250V. CONVENIENCE OUTLET SHALL BE GROUNDING TYPE, RATED 15A, 250V. ALL WIRING DEVICES, ENCLOSED CIRCUIT BREAKER AND EQUIPMENT TO BE USE FOR OUTDOOR SHALL BE OF WEATHER-PROOF TYPE. ELECTRICAL DEVICES & EQUIPMENTS ARE SHOWN ONLY IN ITS APPROXIMATE LOCATION, ACTUAL POSITION SHALL BE VERIFY BY THE ELECTRICAL CONTRACTOR PRIOR TO INSTALLATION.
9. FOR EACH SPARE CIRCUIT IN THE PANELBOARD, PROVIDE AN EMPTY CONDUIT 20mmø (3/4") TERMINATING TO A A COVERED SQUARE BOX WHICH SHALL BE ACCESSIBLE FOR FUTURE USE. PROVIDE PROPER IDENTIFICATION, LABELLING OF ALL CIRCUIT BREAKER AND PANEL DIRECTORY.
10. FOR FIELD CONDITION WHICH REQUIRE DEVIATION IN THE PLAN AND/ OR ANY SUGGESTED CHANGES. THESE SHALL FIRST BE CONSULT TO THE DESIGNER / CONSULTANT FOR APPROVAL.

LEGEND:

-  DECORATIVE CENTER LIGHT
-  RECESSED PANEL LIGHT 40w DAY LIGHT
-  RECESSED SLIM DOWNLIGHT 12w DAY LIGHT
-  RECESSED SLIM DOWNLIGHT 6w WARM WHITE
-  DUAL OPTICS EMERGENCY LIGHT (50w)
-  LED EXIT SIGN
-  CEILING MOUNT EXHAUST FAN (50w)
-  WALL LAMP 100w
-  PANELBOARD / AUX. BOXES (as designated)
-  SINGLE LIGHTING SWITCH
-  2 GANG LIGHTING SWITCH
-  3 GANG LIGHTING SWITCH
-  CIRCUIT RUN IN CEILING, UNDER FLOOR OR WALL
-  LP/01 CIRCUIT HOMERUN TO DESIGNATED PANELBOARD

CONDUCTOR SIZE = FULL LOAD CURRENT x 125%

AWG/MCM	mm ²	IN RACEWAY - AMPACITY				OPEN WIRING - AMPACITY		
		SIZE	TW (60°C)	THW (75°C) THWN	THHN (90°C)	TW (60°C)	THW (75°C) THWN	THHN (90°C)
14	2.0	20	20	30		20	20	30
	2.6	30	30	40		30	30	40
STRANDED SIZE								
12	3.5	20	20	30		30	30	40
10	5.5	30	30	40		40	45	55
8	8.0	40	45	50		55	60	70
6	14	55	65	70		80	95	105
4	22	70	85	90		105	130	140
2	30	90	110	115		130	160	170
1	38	100	125	130		155	185	195
1/0	50	120	145	150		180	220	235
2/0	60	135	160	170		205	250	260
3/0	80	160	185	205		250	300	320
4/0	100	185	220	225		290	355	370
250	125	210	255	265		335	400	420
300	150	240	280	295		375	440	475
400	200	280	330	355		440	540	570
500	250	315	375	400		505	620	655

FEEDER SCHEDULE TWO (2) WIRE SYSTEM W/ GROUND					
FEEDER CODE	WIRE / CABLE	SIZE (inches)	RSC/IMC EMT(mmØ)	PVC equiv. (mmØ)	
X2.0	2-2.0mmø THHN/THWN	1/2"	15mmø	20mmø	
(grnd)	1-1.6mmø THHN/THWN				
X2.6	2-2.6mmø THHN/THWN	3/4"	20mmø	25mmø	
(grnd)	1-2.0mmø THHN/THWN				
STRANDED SIZE					
X3.5	2-3.5mm ² THHN/THWN	1/2"	15mmø	20mmø	
(grnd)	1-2.1mm ² THHN/THWN				
X5.5	2-5.5mm ² THHN/THWN	3/4"	20mmø	25mmø	
(grnd)	1-3.5mm ² THHN/THWN				
X8.0	2-8.0mm ² THHN/THWN	1"	25mmø	32mmø	
(grnd)	1-5.5mm ² THHN/THWN				
X14	2-14mm ² THHN/THWN	1"	25mmø	32mmø	
(grnd)	1-5.5mm ² THHN/THWN				
X22	2-22mm ² THHN/THWN	1-1/4"	32mmø	40mmø	
(grnd)	1-8.0mm ² THHN/THWN				
X30	2-30mm ² THHN/THWN	1-1/4"	32mmø	40mmø	
(grnd)	1-8.0mm ² THHN/THWN				
X38	2-38mm ² THHN/THWN	1-1/2"	40mmø	50mmø	
(grnd)	1-8.0mm ² THHN/THWN				
X50	2-50mm ² THHN/THWN	1-1/2"	40mmø	50mmø	
(grnd)	1-14mm ² THHN/THWN				
X60	2-60mm ² THHN/THWN	2"	50mmø	63mmø	
(grnd)	1-14mm ² THHN/THWN				
X80	2-80mm ² THHN/THWN	2"	50mmø	63mmø	
(grnd)	1-14mm ² THHN/THWN				
X100	2-100mm ² THHN/THWN	2"	50mmø	63mmø	
(grnd)	1- 22mm ² THHN/THWN				
X125	2-125mm ² THHN/THWN	2-1/2"	63mmø	75mmø	
(grnd)	1- 22mm ² THHN/THWN				
X150	2-150mm ² THHN/THWN	2-1/2"	63mmø	75mmø	
(grnd)	1- 30mm ² THHN/THWN				
X200	2-200mm ² THHN/THWN	3"	76mmø	90mmø	
(grnd)	1- 30mm ² THHN/THWN				
X250	2-250mm ² THHN/THWN	3"	76mmø	90mmø	
(grnd)	1- 50mm ² THHN/THWN				
NOTE: (grnd) – ground wire shall be install as required by the system.					


FEEDER SCHEDULE THREE (3) WIRE SYSTEM W/ GROUND					
FEEDER CODE	WIRE / CABLE	SIZE (inches)	RSC/IMC EMT(mmØ)	PVC equiv. (mmØ)	
Y2.0	3-2.0mmø THHN/THWN	1/2"	15mmø	20mmø	
(grnd)	1-1.6mmø THHN/THWN				
Y2.6	3-2.6mmø THHN/THWN	3/4"	20mmø	25mmø	
(grnd)	1-2.0mmø THHN/THWN				
STRANDED SIZE					
Y3.5	3-3.5mm ² THHN/THWN	1/2"	15mmø	20mmø	
(grnd)	1-2.1mm ² THHN/THWN				
Y5.5	3-5.5mm ² THHN/THWN	3/4"	20mmø	25mmø	
(grnd)	1-3.5mm ² THHN/THWN				
Y8.0	3-8.0mm ² THHN/THWN	1"	25mmø	32mmø	
(grnd)	1-5.5mm ² THHN/THWN				
Y14	3-14mm ² THHN/THWN	1"	25mmø	32mmø	
(grnd)	1-5.5mm ² THHN/THWN				
Y22	3-22mm ² THHN/THWN	1-1/4"	32mmø	40mmø	
(grnd)	1-8.0mm ² THHN/THWN				
Y30	3-30mm ² THHN/THWN	1-1/4"	32mmø	40mmø	
(grnd)	1-8.0mm ² THHN/THWN				
Y38	3-38mm ² THHN/THWN	1-1/2"	40mmø	50mmø	
(grnd)	1-8.0mm ² THHN/THWN				
Y50	3-50mm ² THHN/THWN	2"	50mmø	63mmø	
(grnd)	1-14mm ² THHN/THWN				
Y60	3-60mm ² THHN/THWN	2"	50mmø	63mmø	
(grnd)	1-14mm ² THHN/THWN				
Y80	3-80mm ² THHN/THWN	2"	50mmø	63mmø	
(grnd)	1-22mm ² THHN/THWN				
Y100	3-100mm ² THHN/THWN	2-1/2"	63mmø	75mmø	
(grnd)	1- 22mm ² THHN/THWN				
Y125	3-125mm ² THHN/THWN	2-1/2"	63mmø	75mmø	
(grnd)	1- 22mm ² THHN/THWN				
Y150	3-150mm ² THHN/THWN	3"	76mmø	90mmø	
(grnd)	1- 30mm ² THHN/THWN				
Y200	3-200mm ² THHN/THWN	3"	76mmø	90mmø	
(grnd)	1- 30mm ² THHN/THWN				
Y250	3-250mm ² THHN/THWN	4"	100mmø	110mmø	
(grnd)	1- 50mm ² THHN/THWN				
NOTE: (grnd) – ground wire shall be install as required by the system.					

LPB (LIGHTING LOADS)							FEED:	MDP	MOUNT:	SURFACED	KAIC:	10	TYPE:	BOLT-ON		
CKT NO	LOAD DESCRIPTION						VOLT AMPERE	AMPERE RATING				CKT. PRT'N.				SIZE OF FEEDER THHN/THWN
	Panel Lt. 40w	Dn.Lt. 12w	Dn.Lt. 6w	Em.Lt. 50w	C.O. 180w	OTHERS		#AB	#BC	#CA	3ø	P	AT	AF	KAIC	
1	3	24		5			658	2.86				2P	20	50	10	X3.5/PVC
2	12	12		5			874	3.80					20			X3.5/PVC
3		33		5			646			2.81			20			X3.5/PVC
4	6	17		3		2-Exhaust Fan 50w	694			3.02			20			X3.5/PVC
5	8	8		3		1-Center Lt. 100w/2-Exit Lt. 50w	766		3.33				20			X3.5/PVC
6		23		3		2-Exhaust Fan 50w	526		2.29				20			X3.5/PVC
7	5	23		4		1-Center Lt. 100w/1-Exit Lt. 50w	1,190	5.17					20			X3.5/PVC
8	8	12	16	4		2-Exhaust Fan 50w	872	3.79					20			X3.5/PVC
9	10	6	14	3		1-Exhaust Fan 50w	1,056			4.59			20			X3.5/PVC
10						12-Wall Lamp 100w	1,200			5.22			20			X3.5/PVC
11						S P A R E	1,000		4.35				20			X3.5/PVC
12						S P A R E	1,000		4.35				20			X3.5/PVC
TOTAL:							10,482	15.62	14.32	15.64						
COMPUTATION: I = [(1.732 x 15.64)x 0.80 D.F.] = 21.67 amp.																
WIRE SIZING: 21.67 x 1.25 = 27.09 amp.																
USE: Y14 / PVC																
MAIN: 50AT/100AF, 3P, 230V, 60Hz, 10kaic.																
NOTES: THIS PANEL BOARD IS NOT REFLECTED AT THE ACTUAL SITE. THIS LOAD COMPUTATION IS FOR REFERENCE ONLY.																


TAP TO EXISTING BRANCH CIRCUITS


(230 VOLTS, 3P)

LPB

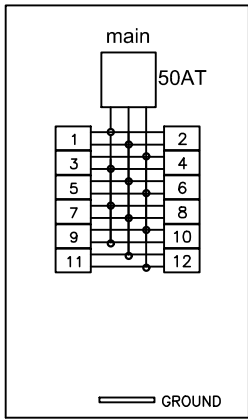




note: all C.B bolt-on type

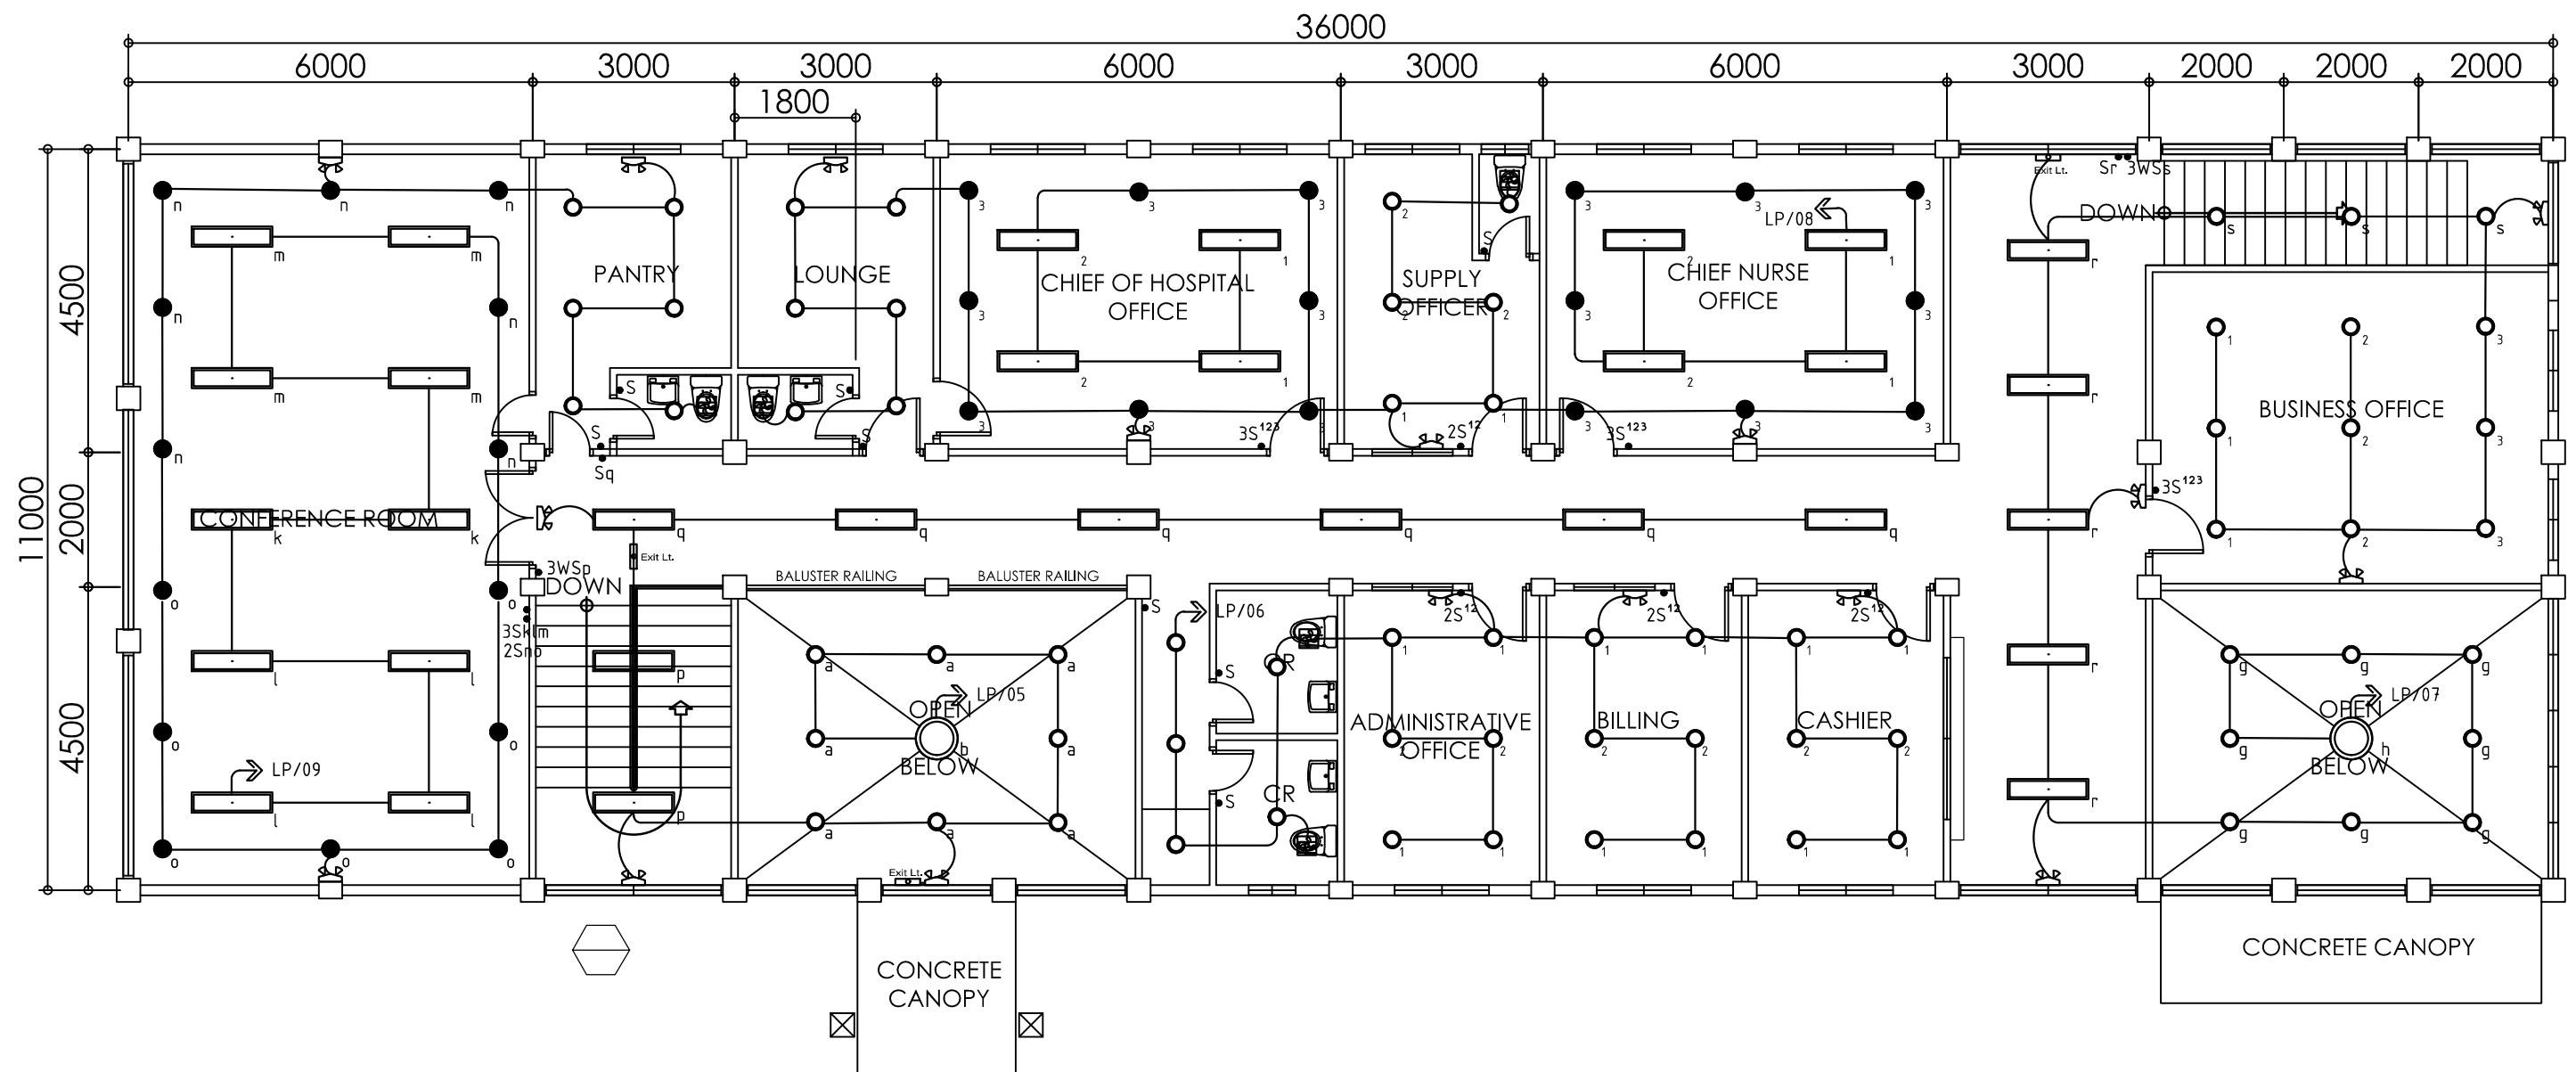 <div>Republic of the Philippines DEPARTMENT OF HEALTH Center for Health Development IV-A CALABARZON DOH-4A, QMMC Compound, Project 4, Quezon City</div>	PROJECT TITLE:	PREPARED BY:	CHECKED BY:	REVIEWED BY:	APPROVED BY:		SHEET CONTENT:	SHEET NUMBER:
	REPAIR/ RENOVATION/ EXTENSION/ CONSTRUCTION/ UPGRADING/ IMPROVEMENT OF HEALTH FACILITIES FOR DON MANUEL LOPEZ MEMORIAL DISTRICT HOSPITAL	JOHN LERY M. PALINES, CE	ERIC JOSE R. MIRAS, RLA	RONALD L. DOROTEO, CE	EDUARDO C. JANAIRI, MD, MPH, CESO III DIRECTOR IV		GENERAL NOTES LOAD SCHEDULE	E-03
	LOCATION : BALAYAN, BATANGAS	ENGINEER II	ARCHITECT III	ENGINEER III / PMU HEAD	RACEL G. CARREON, MM CHIEF ADMINISTRATIVE OFFICER	PAULA PAZ M. SYDIONGCO, MD MPH, CESO IV ASSISTANT REGIONAL DIRECTOR		



1 SECOND FLOOR LIGHTING LAYOUT
 E-02 SCALE 1:100 mts.

 <p>Republic of the Philippines DEPARTMENT OF HEALTH Center for Health Development IV-A CALABARZON DOH-4A, QMMC Compound, Project 4, Quezon City</p> 	PROJECT TITLE: REPAIR/ RENOVATION/ EXTENSION/ CONSTRUCTION/ UPGRADING/ IMPROVEMENT OF HEALTH FACILITIES FOR DON MANUEL LOPEZ MEMORIAL DISTRICT HOSPITAL LOCATION: BALAYAN, BATANGAS	PREPARED BY: JOHN LERY M. PALINES, CE ENGINEER II	CHECKED BY: ERIC JOSE R. MIRAS, RLA ARCHITECT III	REVIEWED BY: RONALD L. DOROTEO, CE ENGINEER III / PMU HEAD	APPROVED BY: EDUARDO C. JANAIR, MD, MPH, CESO III DIRECTOR IV RACEL G. CARREON, MM CHIEF ADMINISTRATIVE OFFICER PAULA PAZ M. SYDIONGCO, MD MPH, CESO IV ASSISTANT REGIONAL DIRECTOR	SHEET CONTENT: SECOND FLOOR LIGHTING LAYOUT	SHEET NUMBER: E-02
-------------------------------------------------------------------------------------------------------------------------------------------------------------------------------------------------------------------------------------------------------------------------------------------------------------------------------------------------------------------------------	------------------------------------------------------------------------------------------------------------------------------------------------------------------------------------------------------------------	-----------------------------------------------------------------------	-----------------------------------------------------------------------	--------------------------------------------------------------------------------	-----------------------------------------------------------------------------------------------------------------------------------------------------------------------------------------------------------------------------	----------------------------------------------------------	-------------------------------------

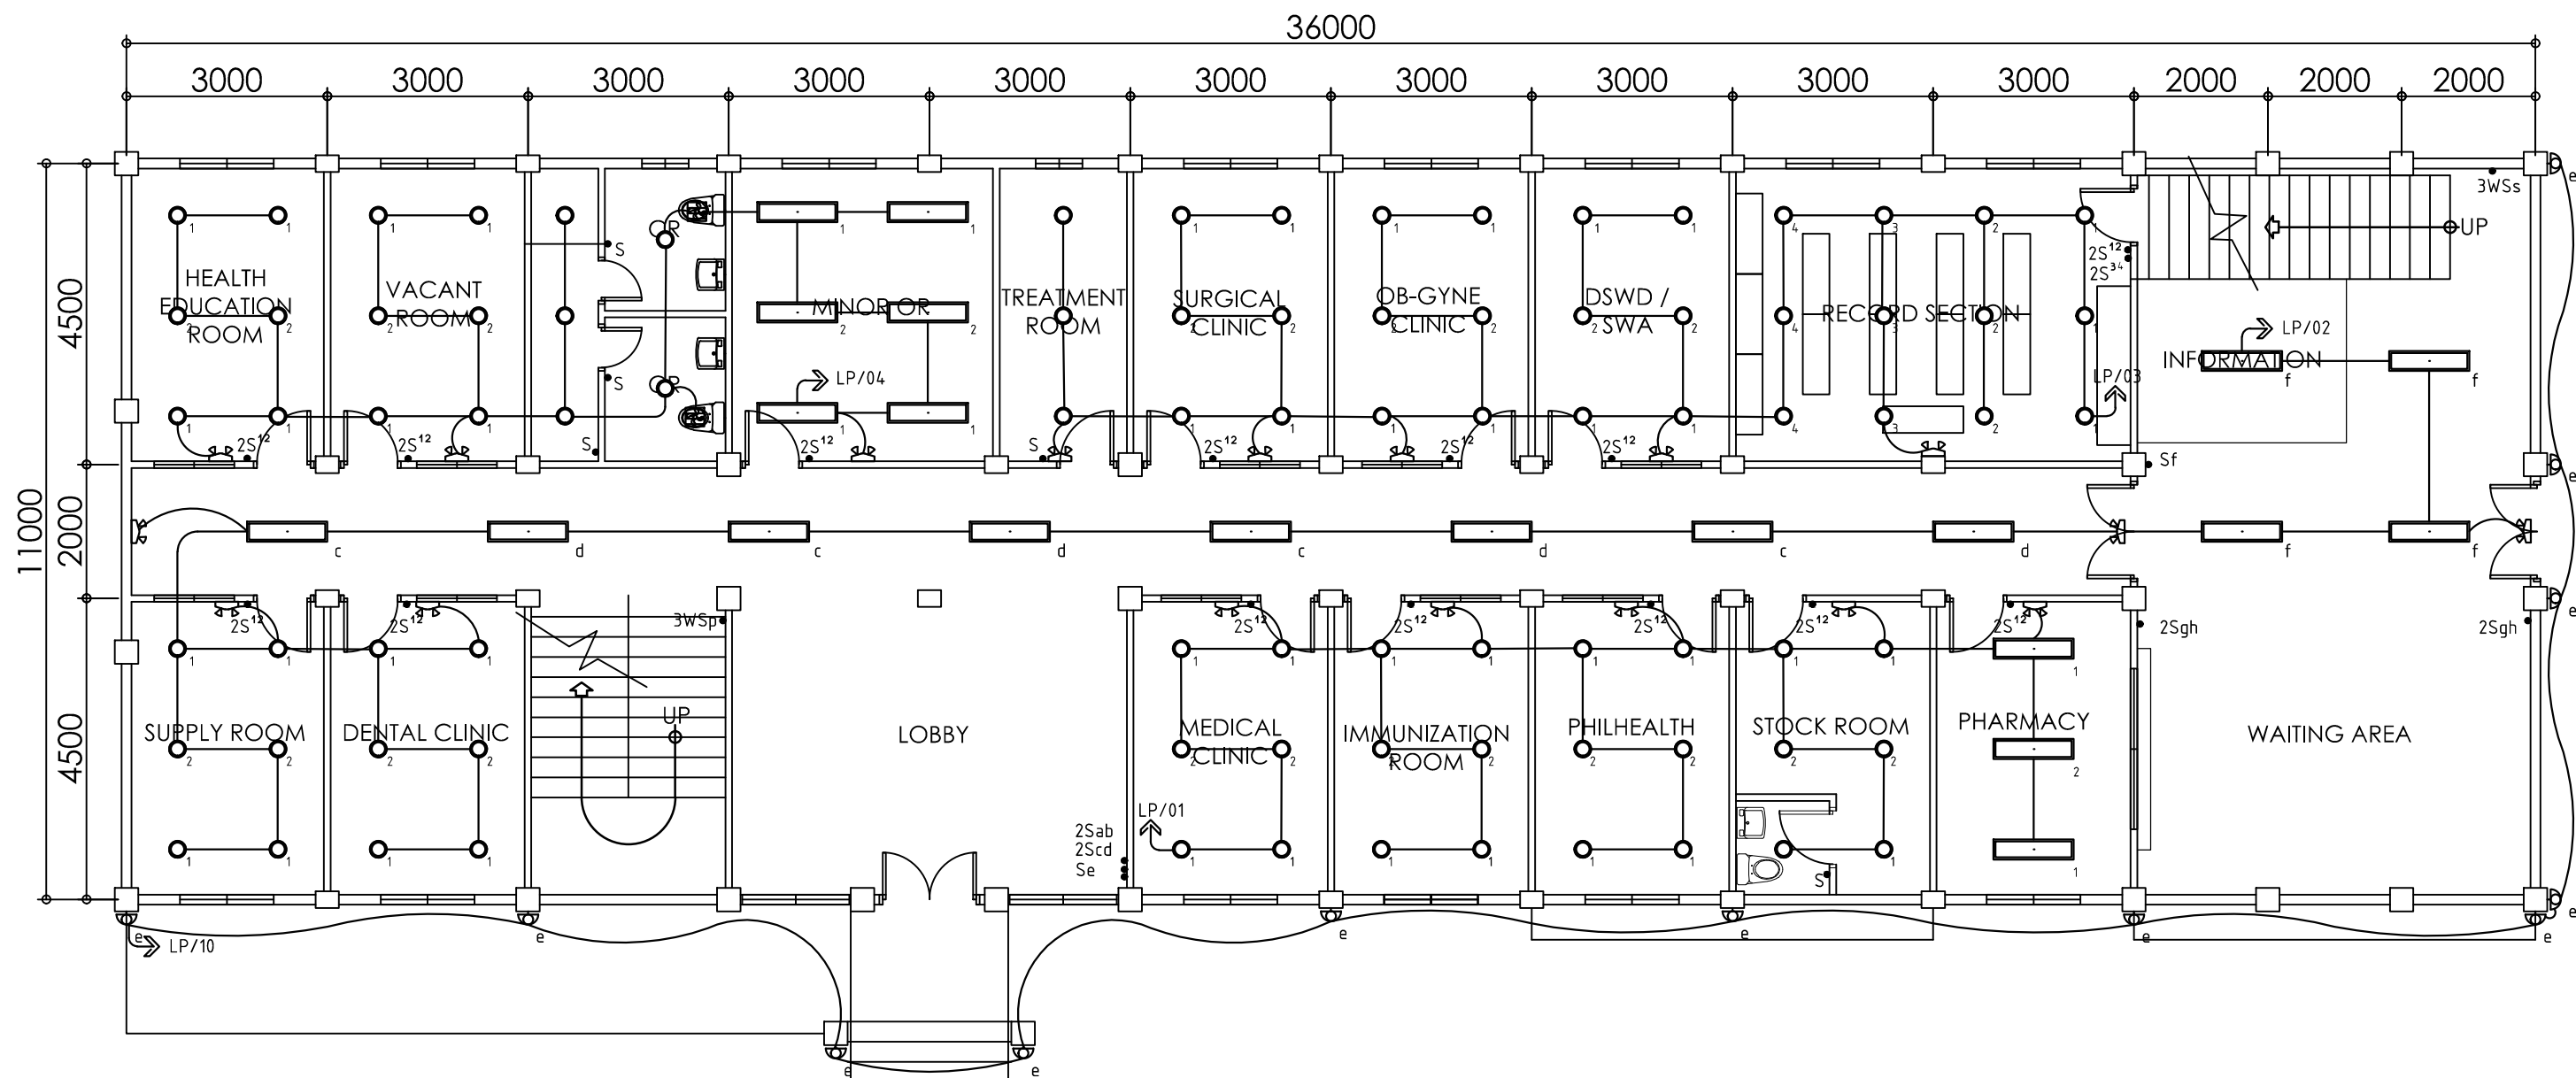

1 **GROUND FLOOR LIGHTING LAYOUT**
E-01 SCALE 1:100 mts.



Republic of the Philippines
DEPARTMENT OF HEALTH
Center for Health Development IV-A
CALABARZON
DOH-4A, QMMC Compound, Project 4, Quezon City




PROJECT TITLE: REPAIR/ RENOVATION/ EXTENSION/ CONSTRUCTION/ UPGRADING/ IMPROVEMENT OF HEALTH FACILITIES FOR DON MANUEL LOPEZ MEMORIAL DISTRICT HOSPITAL	PREPARED BY: JOHN LERY M. PALINES, CE ENGINEER II	CHECKED BY: ERIC JOSE R. MIRAS, RLA ARCHITECT III	REVIEWED BY: RONALD L. DOROTEO, CE ENGINEER III / PMU HEAD	APPROVED BY: EDUARDO C. JANAIRÓ, MD, MPH, CESO III DIRECTOR IV RACEL G. CARREON, MM CHIEF ADMINISTRATIVE OFFICER	SHEET CONTENT: GROUND FLOOR LIGHTING LAYOUT	SHEET NUMBER: E-01
LOCATION : BALAYAN, BATANGAS				PAULA PAZ M. SYDIONGCO, MD MPH, CESO IV ASSISTANT REGIONAL DIRECTOR		



1 LOCATION MAP
CS SCALE NTS.



2 VICINITY MAP
CS SCALE NTS.

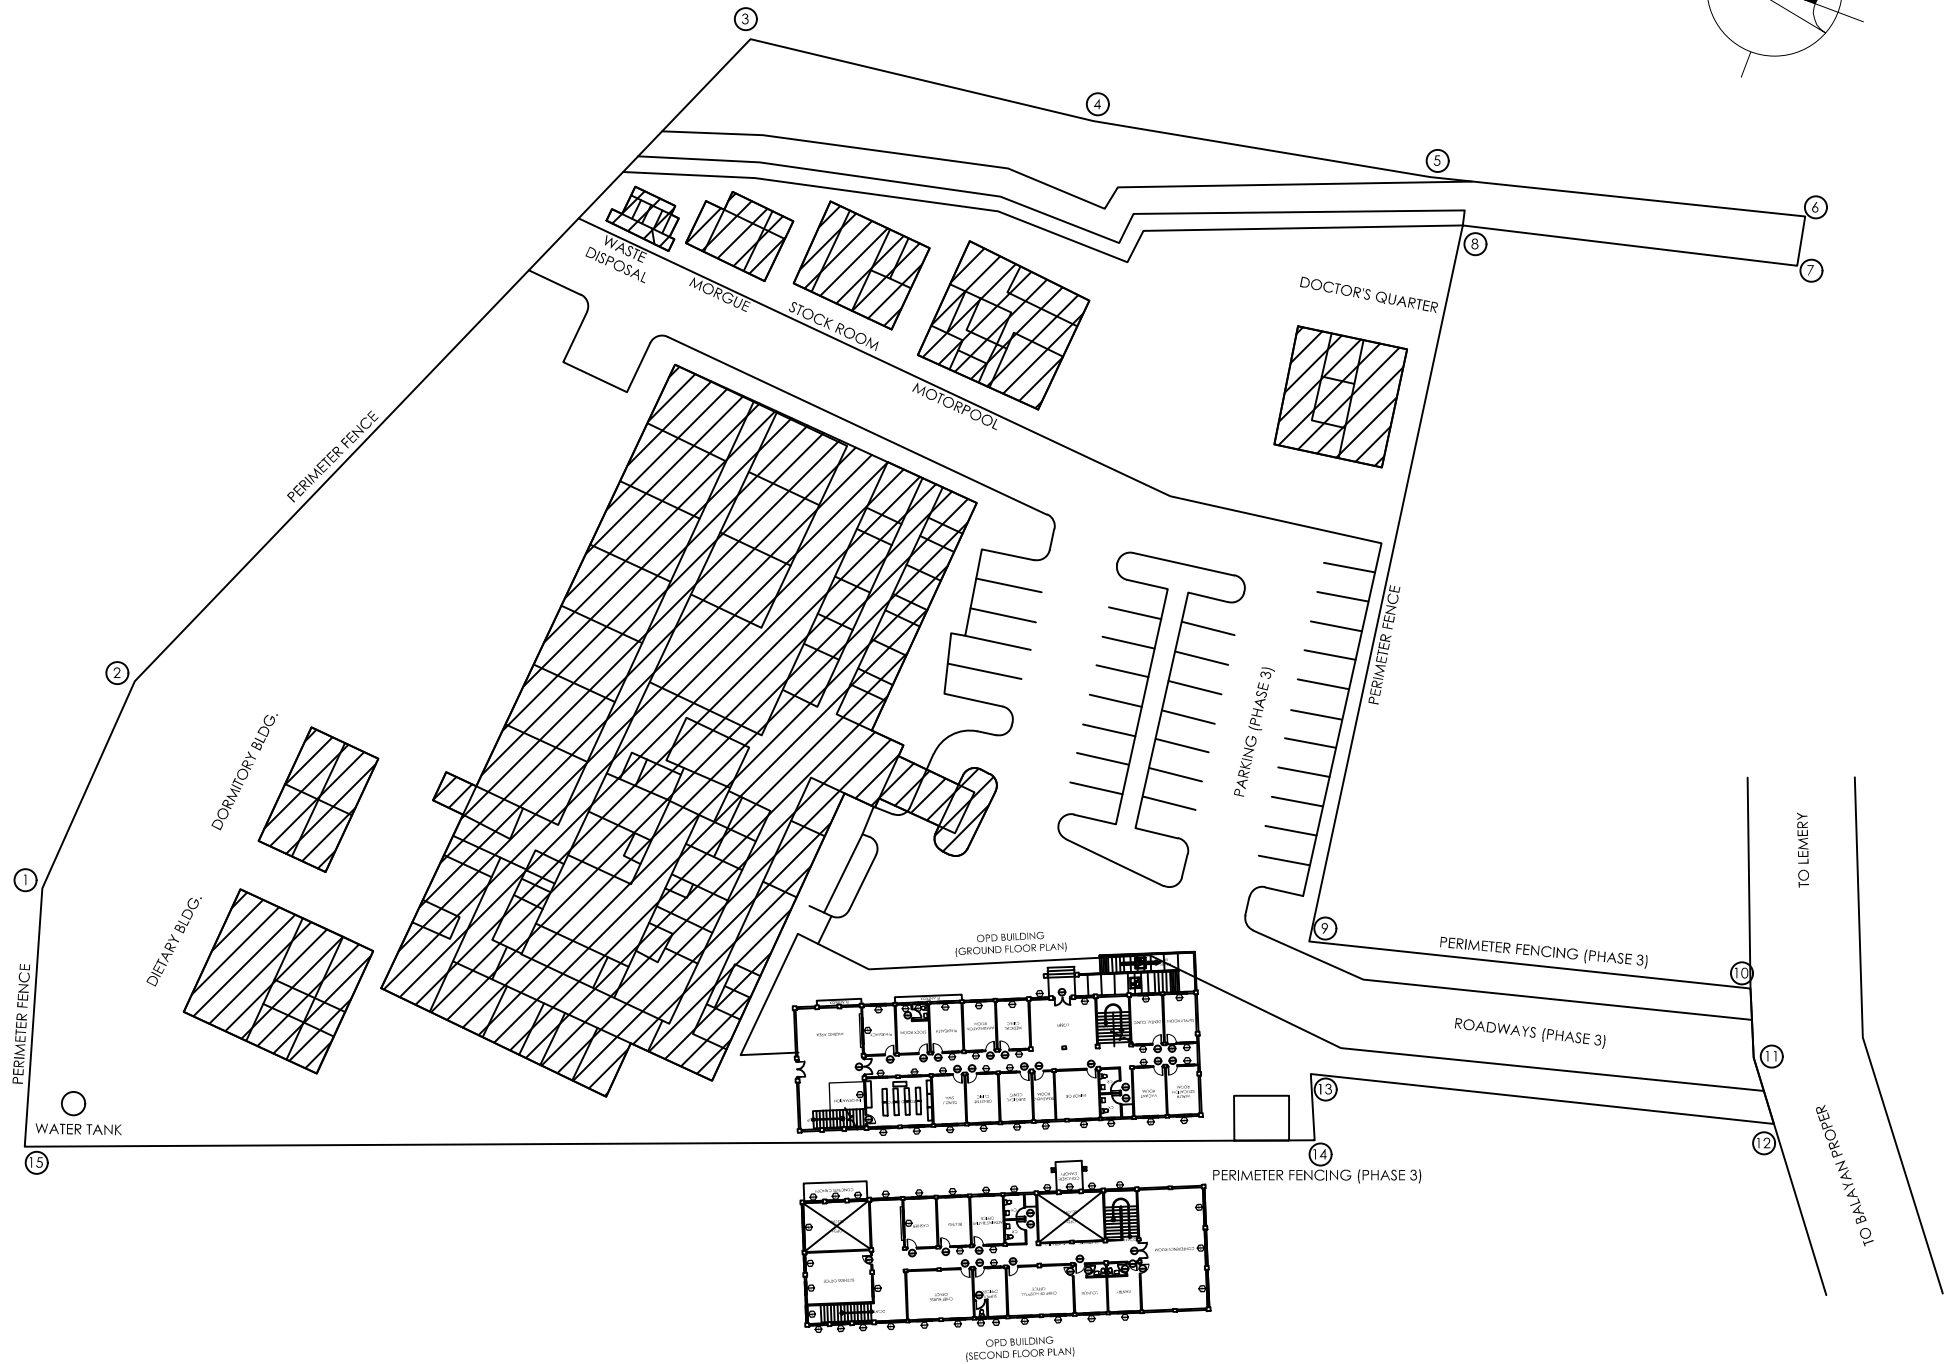


3 SITE DEVELOPMENT PLAN
CS SCALE NTS.





Republic of the Philippines
DEPARTMENT OF HEALTH
Center for Health Development IV-A
CALABARZON
DOH-4A, QMMC Compound, Project 4, Quezon City

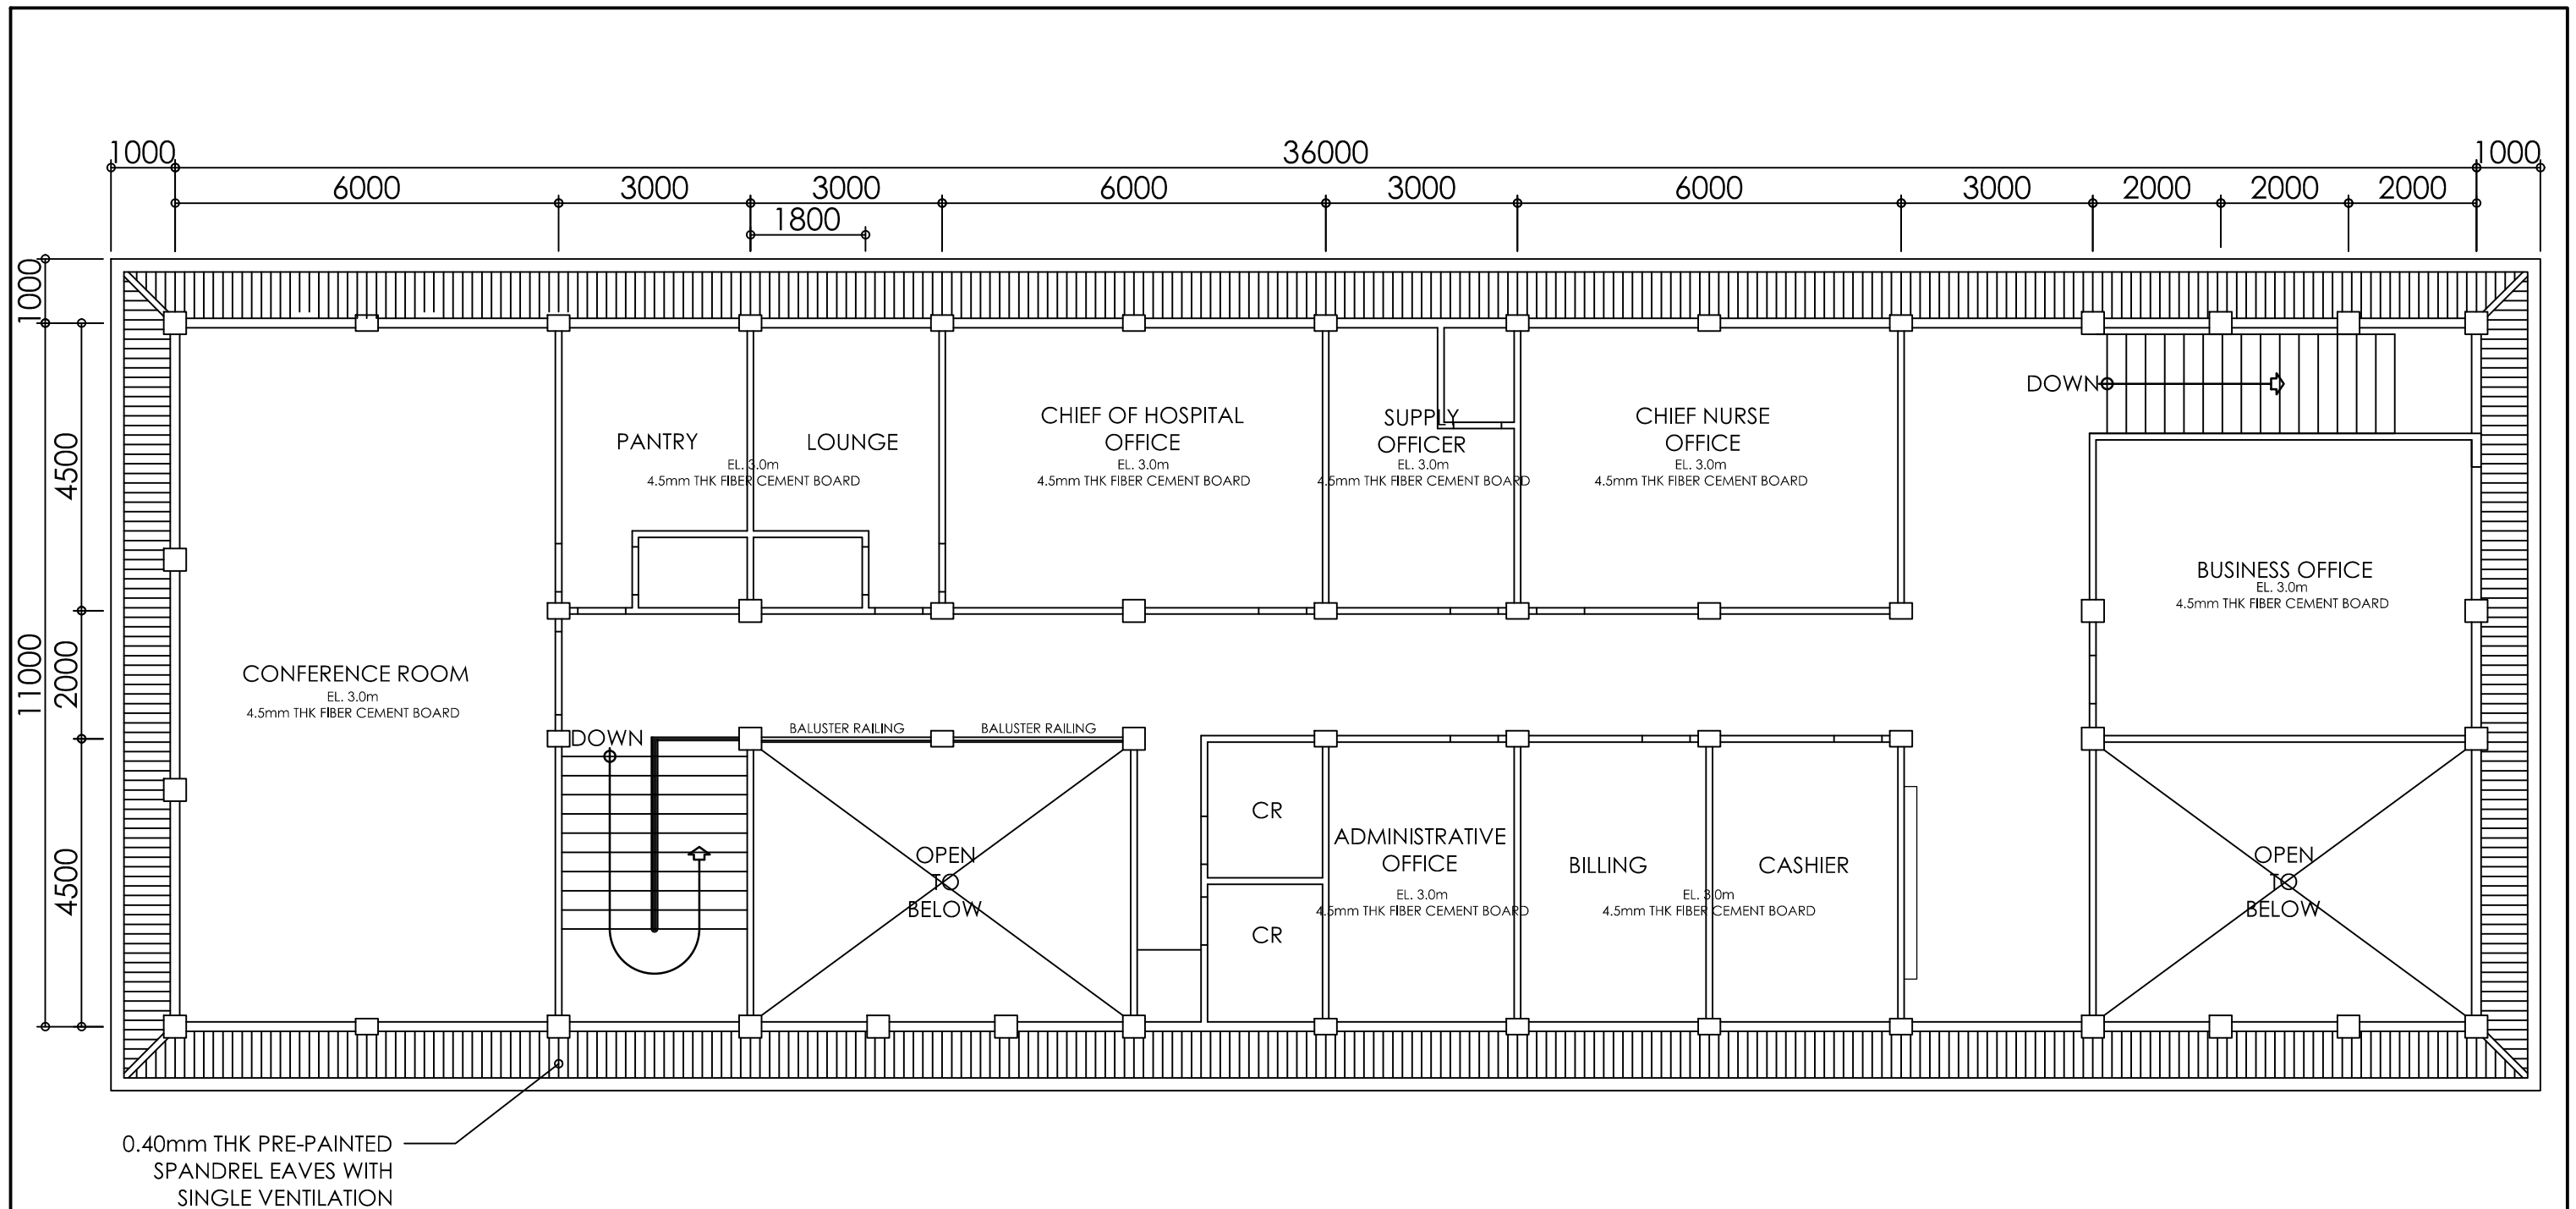


PROJECT TITLE:	PREPARED BY:	CHECKED BY:	REVIEWED BY:	APPROVED BY:	SHEET CONTENT:	SHEET NUMBER:
REPAIR/ RENOVATION/ EXTENSION/ CONSTRUCTION/ UPGRADING/ IMPROVEMENT OF HEALTH FACILITIES FOR DON MANUEL LOPEZ MEMORIAL DISTRICT HOSPITAL	JOHN LERY M. PALINES, CE ENGINEER II	ERIC JOSE R. MIRAS, RLA ARCHITECT III	RONALD L. DOROTEO, CE ENGINEER III / PMU HEAD	EDUARDO C. JANAIRÓ, MD, MPH, CESO III DIRECTOR IV RACEL G. CARREON, MM CHIEF ADMINISTRATIVE OFFICER PAULA PAZ M. SYDIONGCO, MD MPH, CESO IV ASSISTANT REGIONAL DIRECTOR	LOCATION MAP VICINITY MAP SITE DEVELOPMENT PLAN	CS
LOCATION : BALAYAN, BATANGAS						



1 SECOND FLOOR REFLECTED CEILING PLAN
A-08 SCALE 1:100 mts.

 <p>Republic of the Philippines DEPARTMENT OF HEALTH Center for Health Development IV-A CALABARZON DOH-4A, QMMC Compound, Project 4, Quezon City</p> 	PROJECT TITLE: REPAIR/ RENOVATION/ EXTENSION/ CONSTRUCTION/ UPGRADING/ IMPROVEMENT OF HEALTH FACILITIES FOR DON MANUEL LOPEZ MEMORIAL DISTRICT HOSPITAL LOCATION : BALAYAN, BATANGAS	PREPARED BY: JOHN LERY M. PALINES, CE ENGINEER II	CHECKED BY: ERIC JOSE R. MIRAS, RLA ARCHITECT III	REVIEWED BY: RONALD L. DOROTEO, CE ENGINEER III / PMU HEAD	APPROVED BY: EDUARDO C. JANAIRÓ, MD, MPH, CESO III DIRECTOR IV RACEL G. CARREON, MM CHIEF ADMINISTRATIVE OFFICER PAULA PAZ M. SYDIONGCO, MD MPH, CESO IV ASSISTANT REGIONAL DIRECTOR	SHEET CONTENT: SECOND FLOOR REFLECTED CEILING PLAN	SHEET NUMBER: A-08

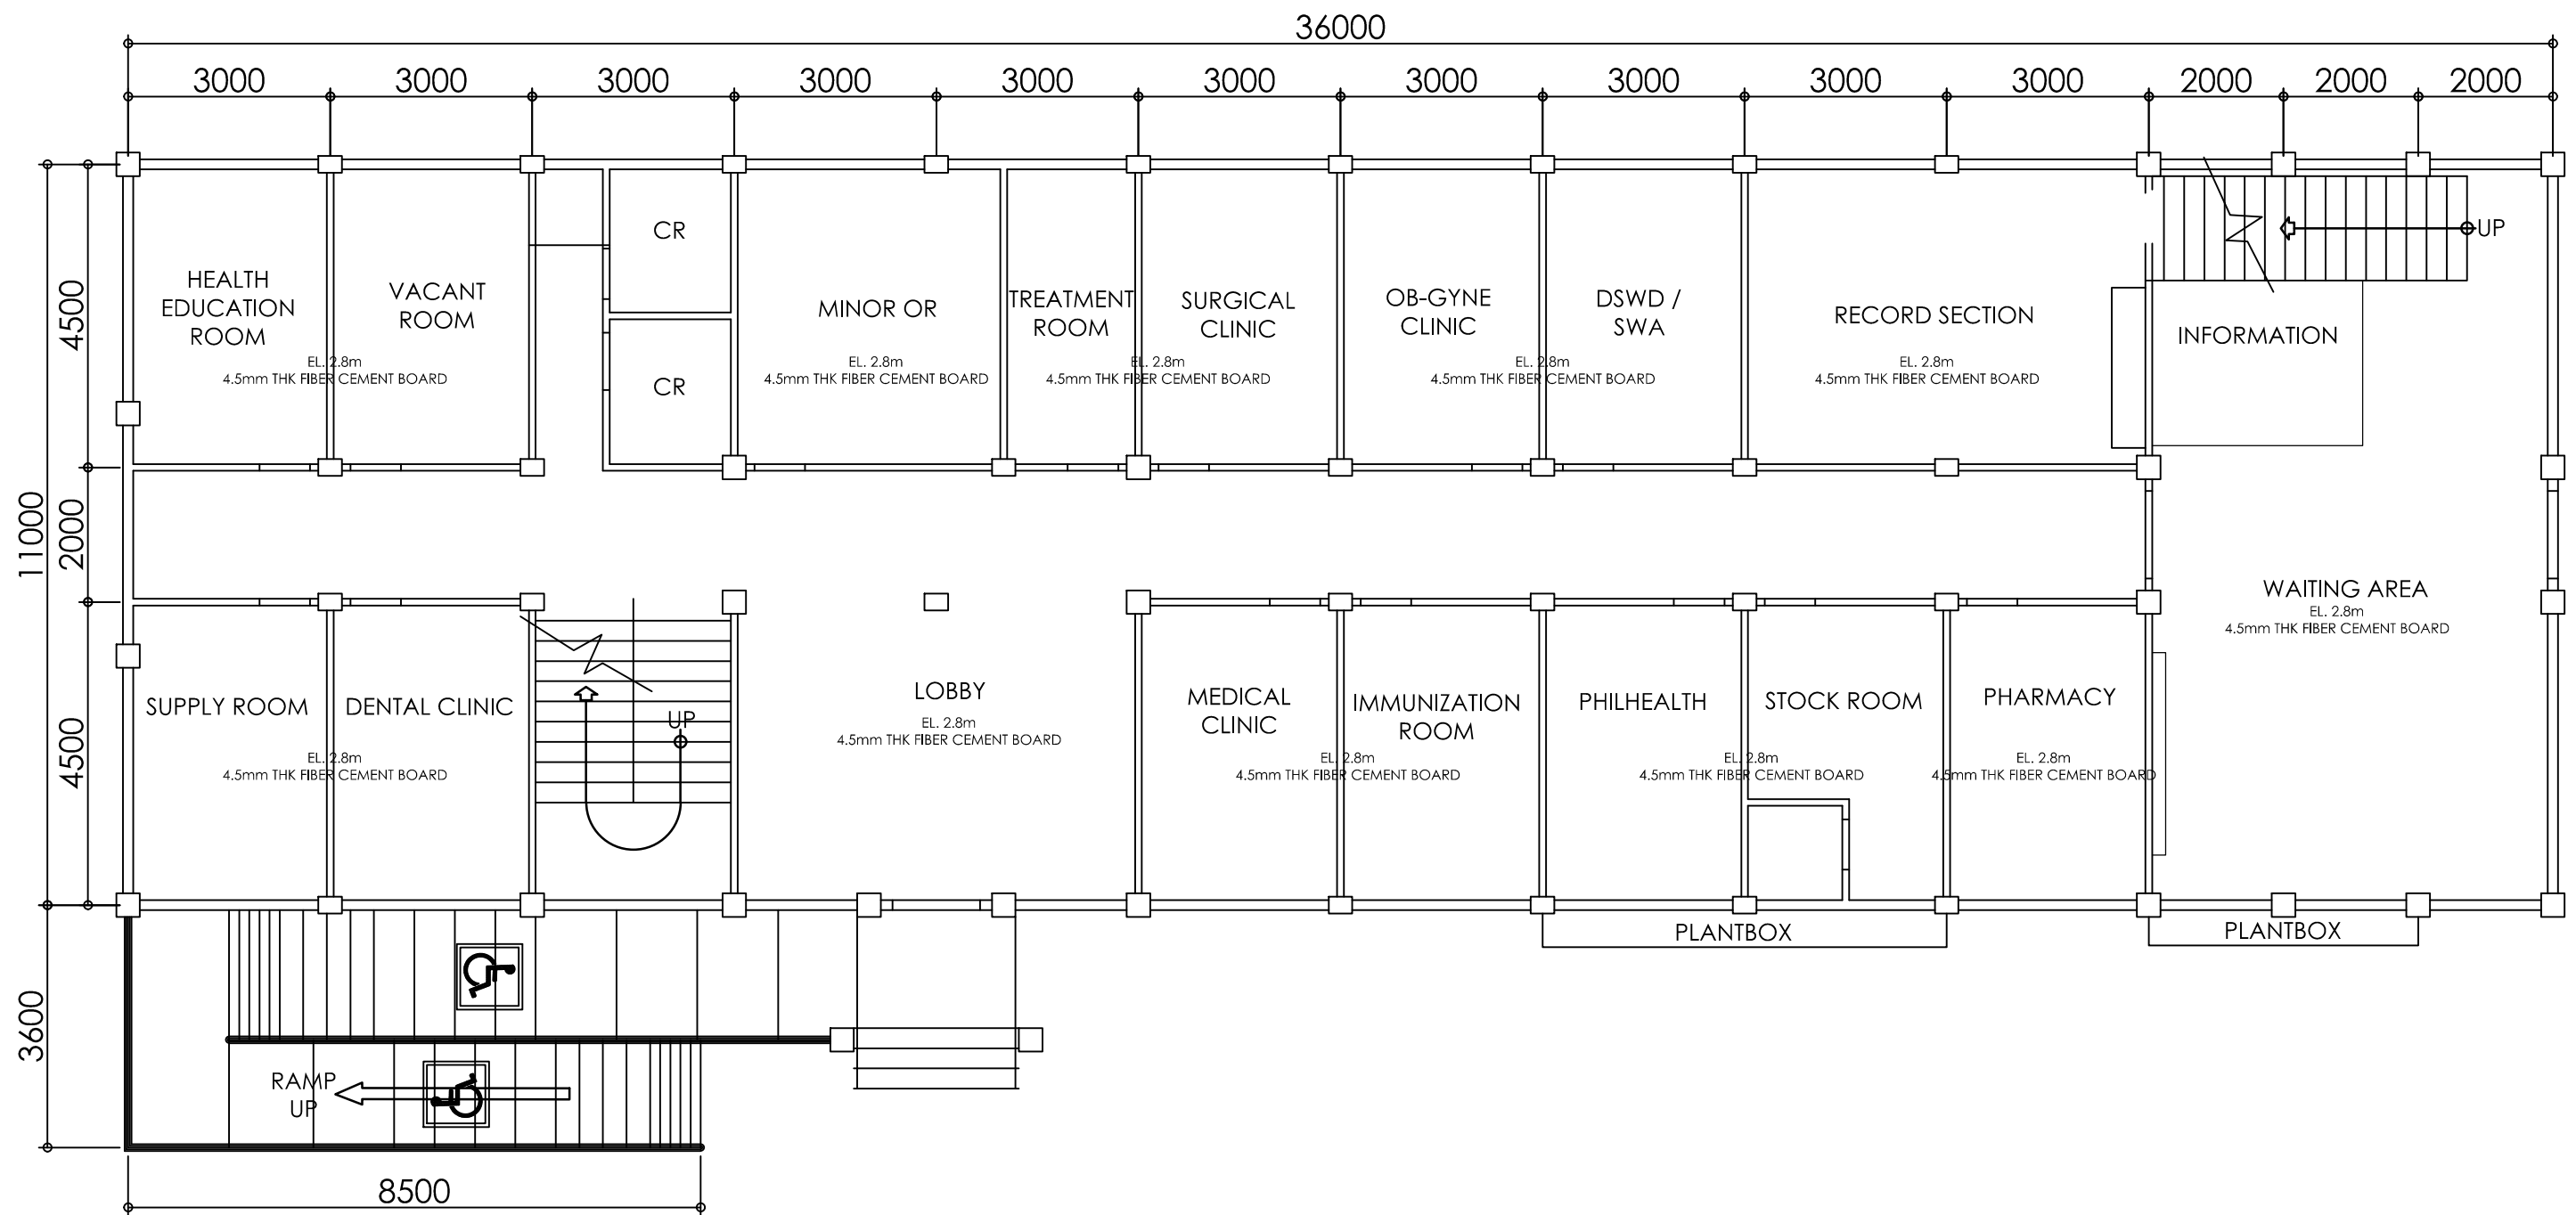


1 GROUND FLOOR REFLECTED CEILING PLAN
A-07 SCALE 1:100 mts.




Republic of the Philippines
DEPARTMENT OF HEALTH
Center for Health Development IV-A
CALABARZON
DOH-4A, QMMC Compound, Project 4, Quezon City




PROJECT TITLE: REPAIR/ RENOVATION/ EXTENSION/ CONSTRUCTION/ UPGRADING/ IMPROVEMENT OF HEALTH FACILITIES FOR DON MANUEL LOPEZ MEMORIAL DISTRICT HOSPITAL LOCATION : BALAYAN, BATANGAS	PREPARED BY: JOHN LERY M. PALINES, CE ENGINEER II	CHECKED BY: ERIC JOSE R. MIRAS, RLA ARCHITECT III	REVIEWED BY: RONALD L. DOROTEO, CE ENGINEER III / PMU HEAD	APPROVED BY: EDUARDO C. JANAIR, MD, MPH, CESO III DIRECTOR IV RACEL G. CARREON, MM CHIEF ADMINISTRATIVE OFFICER PAULA PAZ M. SYDIONGCO, MD MPH, CESO IV ASSISTANT REGIONAL DIRECTOR	SHEET CONTENT: GROUND FLOOR REFLECTED CEILING PLAN	SHEET NUMBER: A-07
-----------------------------------------------------------------------------------------------------------------------------------------------------------------------------------------------------	---------------------------------------------------------	---------------------------------------------------------	------------------------------------------------------------------	-------------------------------------------------------------------------------------------------------------------------------------------------------------------------------------------------------	----------------------------------------------------------	-----------------------

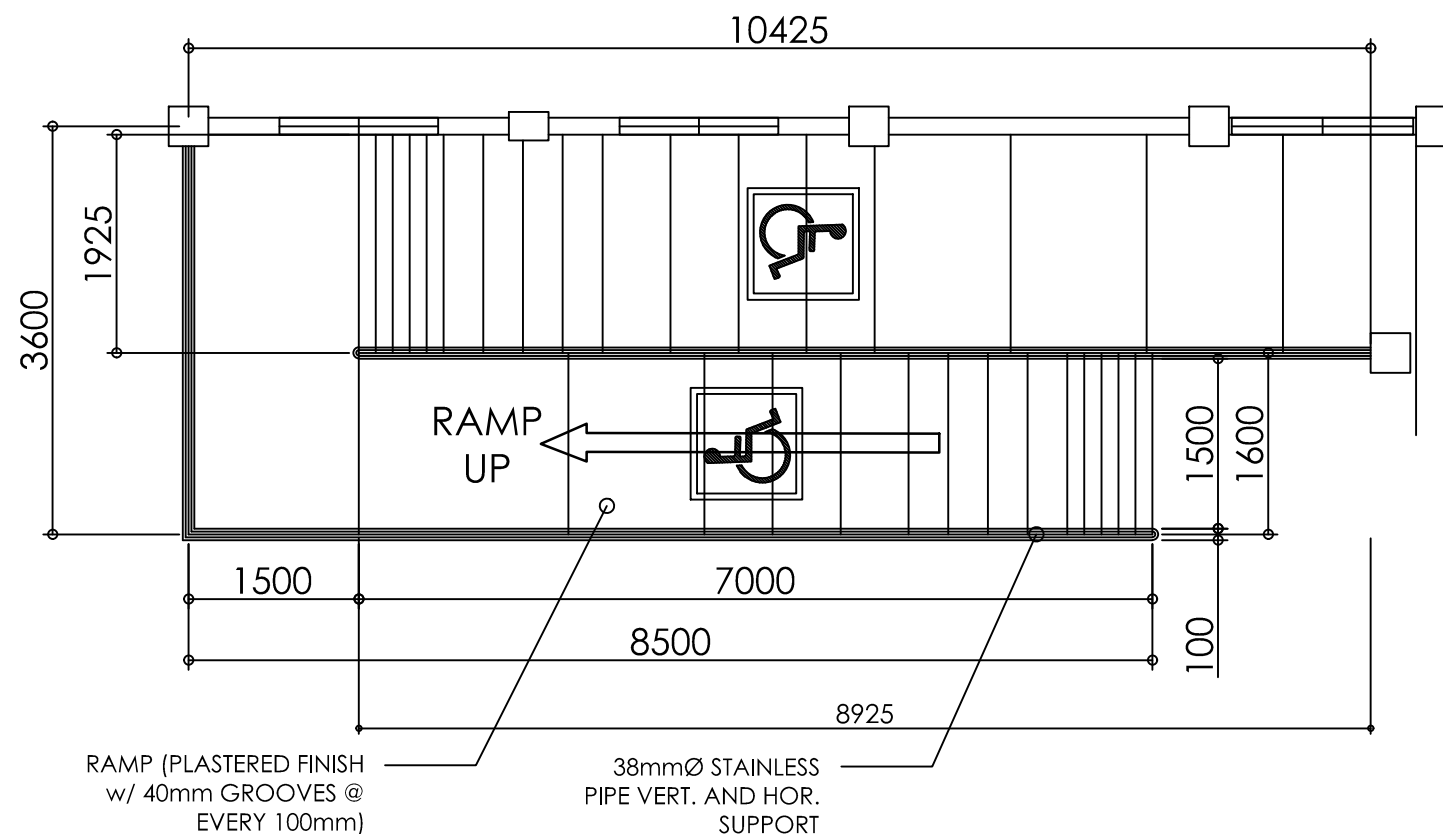


1 RAMP PLAN DETAIL
A-06 SCALE 1:50 mts.

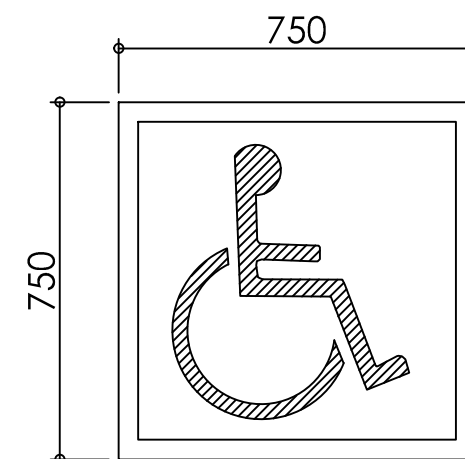

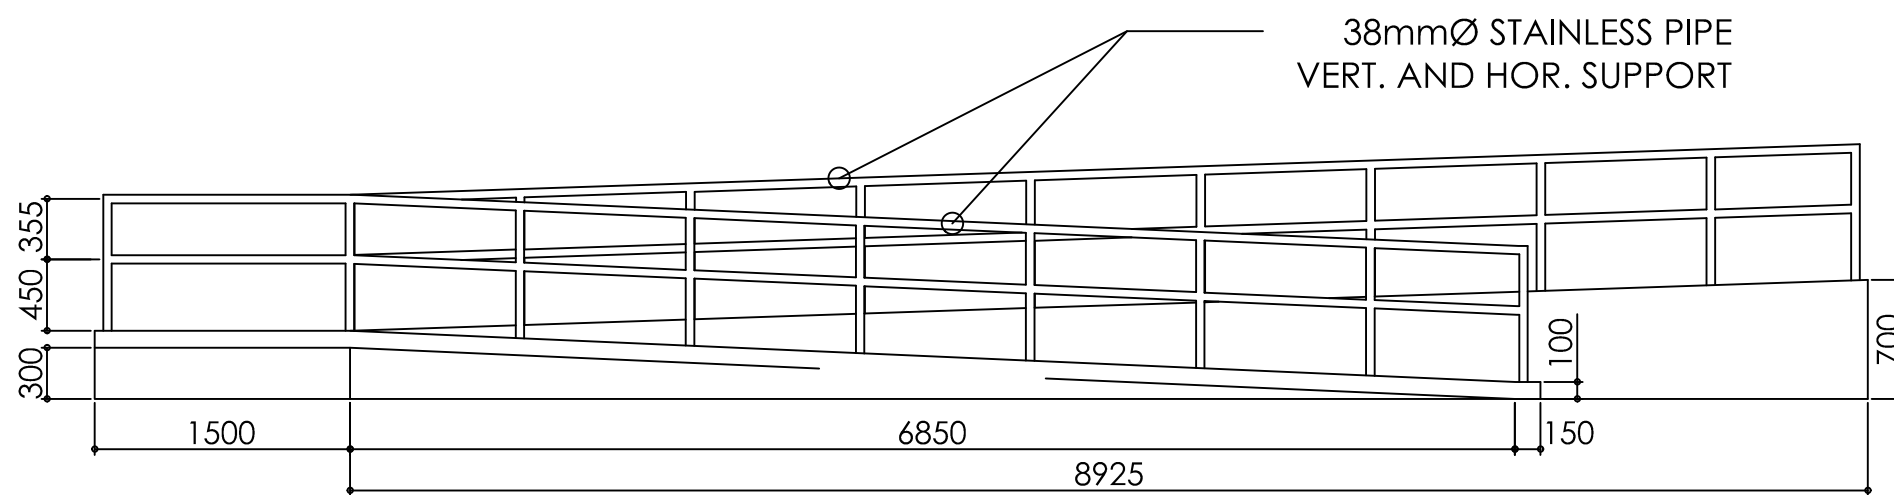

2 PWD LOGO
A-06 SCALE 1:25 mts.

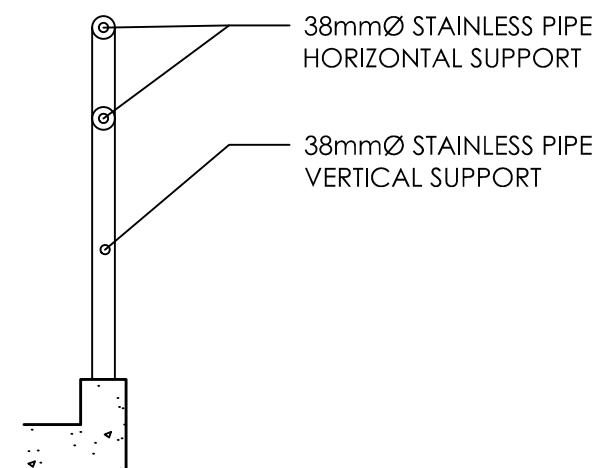


3 RAMP ELEVATION DETAIL
A-06 SCALE 1:50 mts.




4 RAMP RAILING DETAIL
A-06 SCALE 1:25 mts.

 <p>Republic of the Philippines DEPARTMENT OF HEALTH Center for Health Development IV-A CALABARZON DOH-4A, QMMC Compound, Project 4, Quezon City</p> 	<p>PROJECT TITLE: REPAIR/ RENOVATION/ EXTENSION/ CONSTRUCTION/ UPGRADING/ IMPROVEMENT OF HEALTH FACILITIES FOR DON MANUEL LOPEZ MEMORIAL DISTRICT HOSPITAL LOCATION : BALAYAN, BATANGAS</p>	<p>PREPARED BY: JOHN LERY M. PALINES, CE ENGINEER II</p>	<p>CHECKED BY: ERIC JOSE R. MIRAS, RLA ARCHITECT III</p>	<p>REVIEWED BY: RONALD L. DOROTEO, CE ENGINEER III / PMU HEAD</p>	<p>APPROVED BY: EDUARDO C. JANAIRO, MD, MPH, CESO III DIRECTOR IV RACEL G. CARREON, MM CHIEF ADMINISTRATIVE OFFICER PAULA PAZ M. SYDIONGCO, MD MPH, CESO IV ASSISTANT REGIONAL DIRECTOR</p>	<p>SHEET CONTENT: RAMP PLAN DETAIL PWD LOGO RAMP ELEVATION DETAIL RAMP RAILING DETAIL</p>	<p>SHEET NUMBER: A-06</p>
--------------------------------------------------------------------------------------------------------------------------------------------------------------------------------------------------------------------------------------------------------------------------------------------------------------------------------------------	-----------------------------------------------------------------------------------------------------------------------------------------------------------------------------------------------------------------	-----------------------------------------------------------------------	-----------------------------------------------------------------------	--------------------------------------------------------------------------------	--------------------------------------------------------------------------------------------------------------------------------------------------------------------------------------------------------------------------	-----------------------------------------------------------------------------------------------------------	------------------------------------


 W1		 W2		 W3		 W4		 W5		 W6		 W7		 W8										
TYPE	AWNING W/ FIXED WINDOW			SLIDING WINDOW W/ TRANSOM			AWNING W/ FIXED WINDOW			SLIDING W/ FIXED WINDOW			FIXED GLASS WINDOW			FIXED GLASS WINDOW			FIXED GLASS WINDOW					
FRAMING	ANALOK ALUMINUM			ANALOK ALUMINUM			ANALOK ALUMINUM			ANALOK ALUMINUM			ANALOK ALUMINUM			ANALOK ALUMINUM			ANALOK ALUMINUM					
GLAZING	6mm THK. CLEAR GLASS			6mm THK. CLEAR GLASS			6mm THK. CLEAR GLASS			6mm THK. CLEAR GLASS			6mm THK. CLEAR GLASS			6mm THK. CLEAR GLASS			6mm THK. CLEAR GLASS					
QUANTITY	3 SETS			24 SETS			2 SETS			6 SETS			3 SETS			13 SETS			1 SET			0 SET		
LOCATION	STAIR LANDING, WAITING AREA			STAIR LANDING, WAITING AREA			LOBBY			TOILET, TREATMENT ROOM, ETC.			CASHIER, PHARMACY, RECORDS			TREATMENT ROOMS, PHILHEALTH, ETC.			BUSINESS OFFICE			BUSINESS OFFICE		
 W9		 W10				 W11		 W12		 W13				 W14										
TYPE	AWNING W/ FIXED WINDOW			AWNING W/ FIXED WINDOW			AWNING W/ FIXED WINDOW			FIXED GLASS WINDOW			FIXED GLASS WINDOW			SLIDING W/ FIXED WINDOW								
FRAMING	ANALOK ALUMINUM			ANALOK ALUMINUM			ANALOK ALUMINUM			ANALOK ALUMINUM			ANALOK ALUMINUM			ANALOK ALUMINUM								
GLAZING	6mm THK. CLEAR GLASS			6mm THK. CLEAR GLASS			6mm THK. CLEAR GLASS			6mm THK. CLEAR GLASS			6mm THK. CLEAR GLASS			6mm THK. CLEAR GLASS								
QUANTITY	9 SETS			3 SETS			2 SETS			1 SET			1 SET			2 SET								
LOCATION	STAIR LANDING, WAITING AREA			CONFERENCE ROOM			BUSINESS OFFICE			RIGHT STAIR WELL			OPEN AIR LOBBY			RECORDS								
 D1		 D2		 D3		 D4		 D5		<div><div>1</div><div>SCHEDULE OF DOORS AND WINDOWS</div><div>A-05 SCALE</div><div>NTS.</div></div>														
TYPE		TWO - LEAF GLASS DOOR		SINGLE PANEL DOOR		TWO - LEAF DOUBLE PANEL DOOR		SINGLE LEAF uPVC DOOR W/ LOUVER												SINGLE LEAF uPVC DOOR W/ LOUVER				
FRAMING		ANALOK ALUMINUM		YAKAL WOOD		YAKAL WOOD		uPVC												uPVC				
GLAZING		6mm THK. CLEAR GLASS		NONE		NONE		NONE												NONE				
QUANTITY		2 SETS		26 SETS		1 SET		7 SETS												1 SETS				
LOCATION		HALLWAY, LOBBY		CONSULTATION & TREATMENT		CONFERENCE		TOILET												PWD TOILET				
 Republic of the Philippines DEPARTMENT OF HEALTH Center for Health Development IV-A CALABARZON DOH-4A, QMMC Compound, Project 4, Quezon City		 PROJECT TITLE: REPAIR/ RENOVATION/ EXTENSION/ CONSTRUCTION/ UPGRADING/ IMPROVEMENT OF HEALTH FACILITIES FOR DON MANUEL LOPEZ MEMORIAL DISTRICT HOSPITAL LOCATION : BALAYAN, BATANGAS		PREPARED BY: JOHN LERY M. PALINES, CE ENGINEER II		CHECKED BY: ERIC JOSE R. MIRAS, RLA ARCHITECT III		REVIEWED BY: RONALD L. DOROTEO, CE ENGINEER III / PMU HEAD		APPROVED BY: EDUARDO C. JANAIRÓ, MD, MPH, CESO III DIRECTOR IV RACEL G. CARREON, MM CHIEF ADMINISTRATIVE OFFICER PAULA PAZ M. SYDIONGCO, MD MPH, CESO IV ASSISTANT REGIONAL DIRECTOR			SHEET CONTENT: SCHEDULE OF DOORS AND WINDOWS		SHEET NUMBER: A-05									

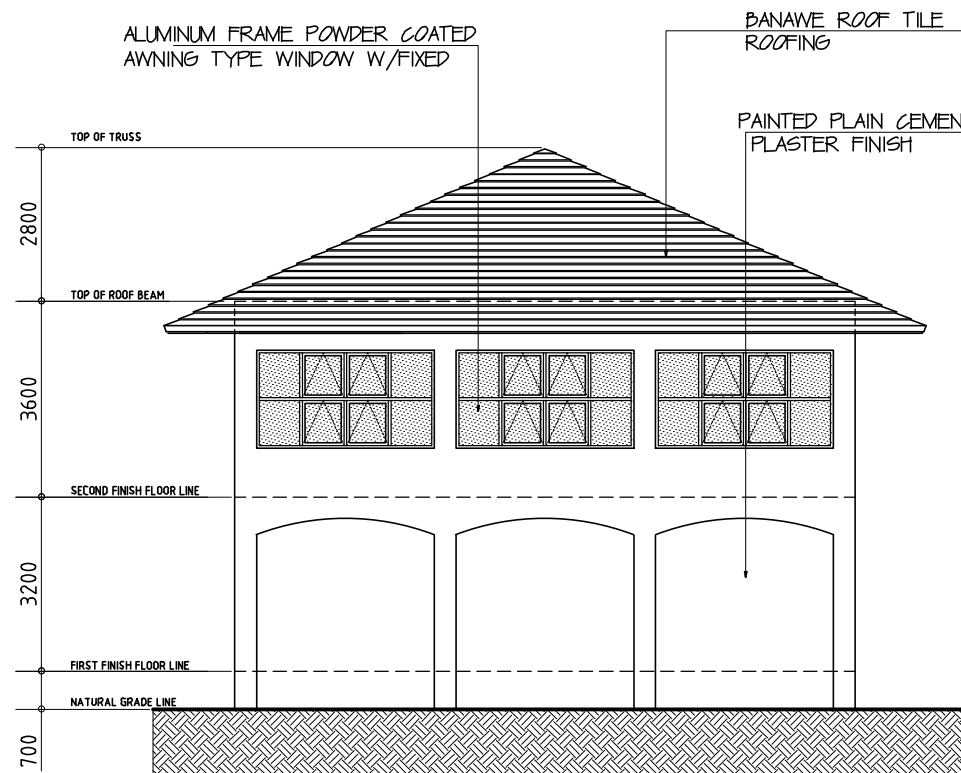


1 LEFT-SIDE ELEVATION
A-04 SCALE NTS.

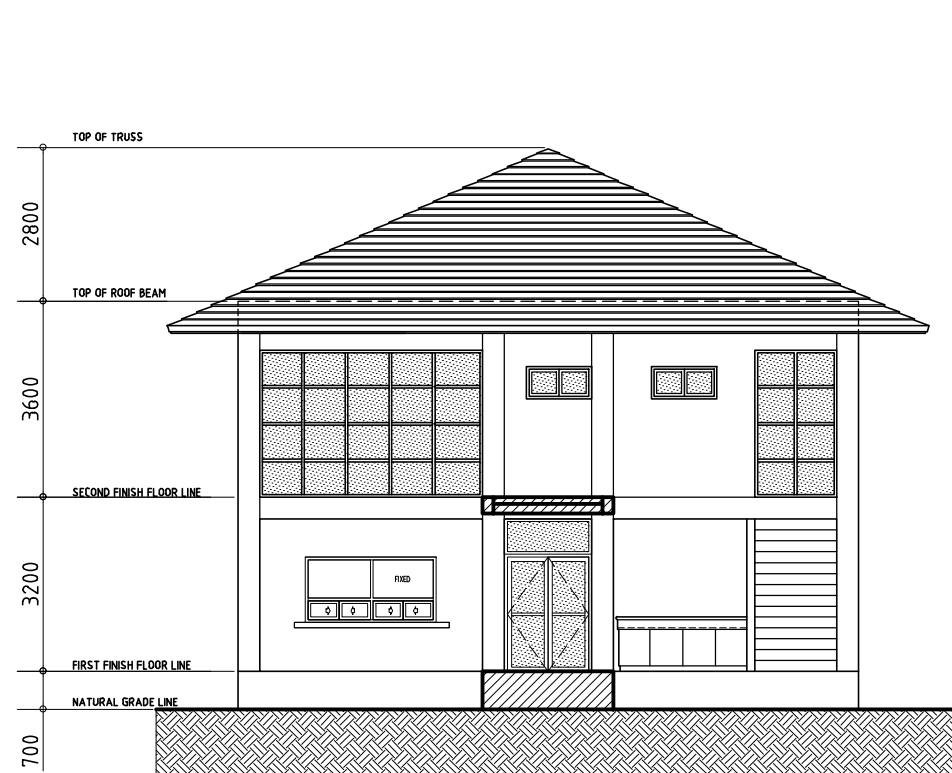

2 RIGHT-SIDE ELEVATION
A-04 SCALE NTS.

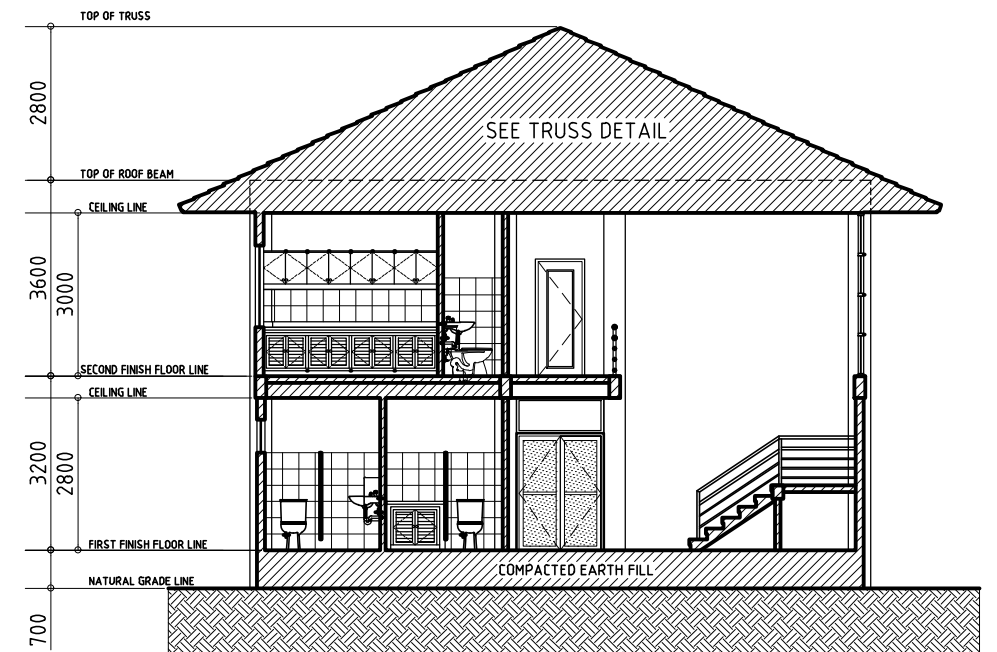

3 CROSS SECTION
A-04 SCALE NTS.

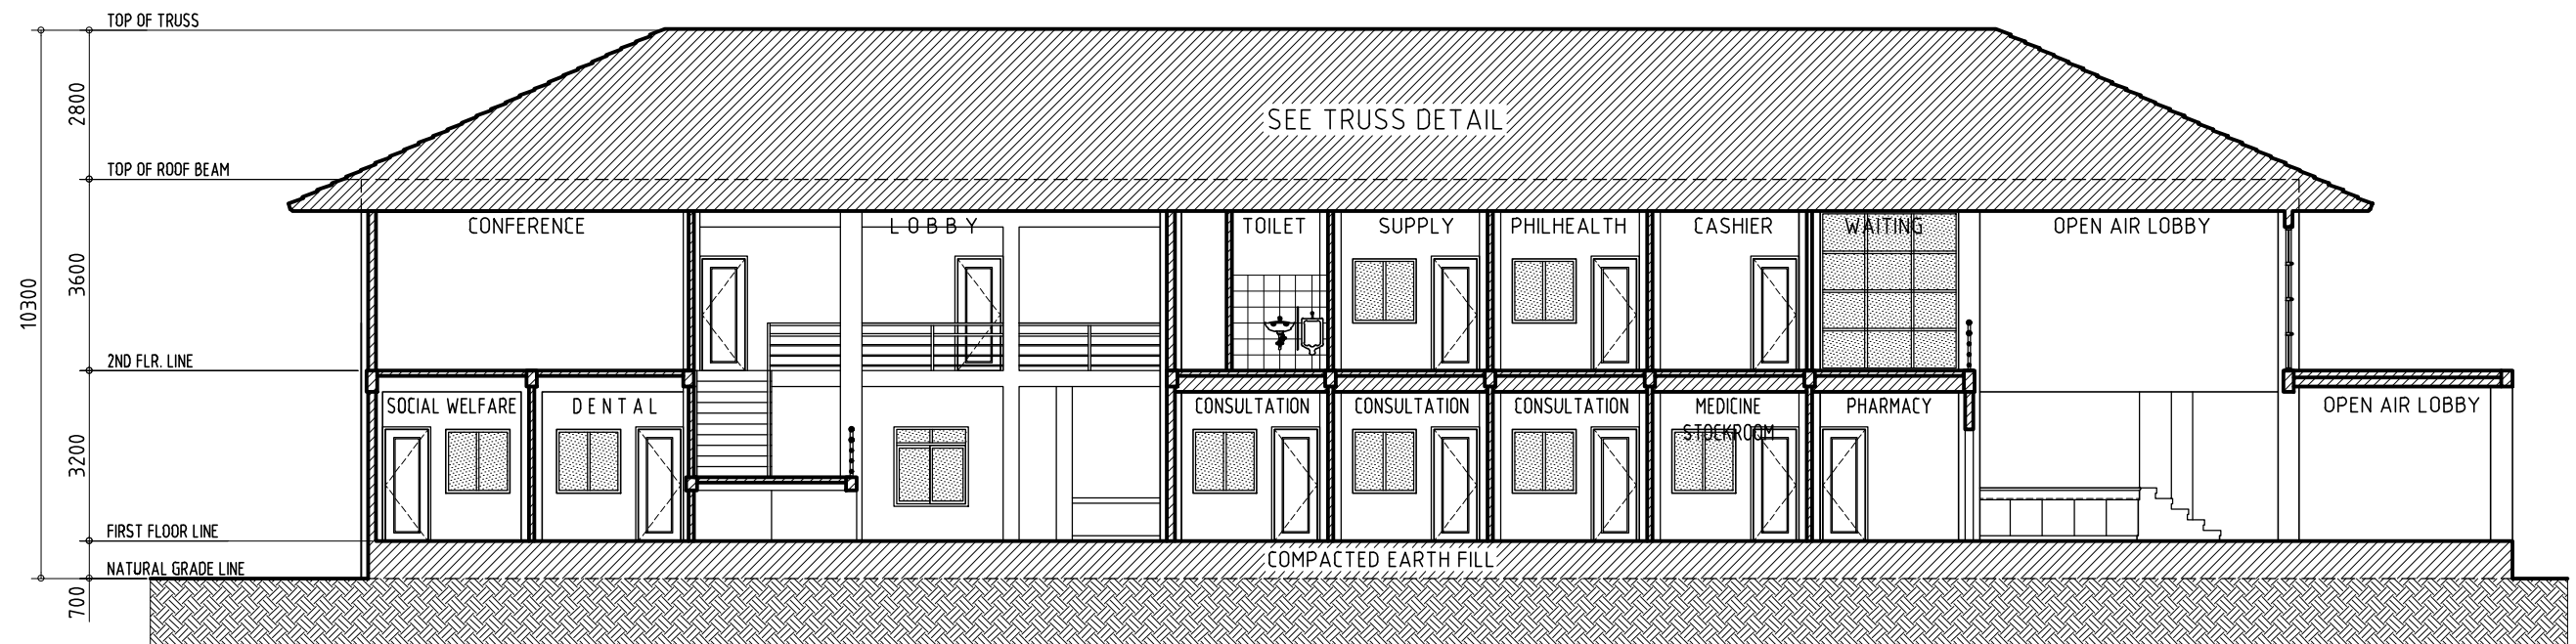

4 LONGITUDINAL SECTION
A-04 SCALE NTS.




Republic of the Philippines
DEPARTMENT OF HEALTH
Center for Health Development IV-A
CALABARZON
DOH-4A, QMMC Compound, Project 4, Quezon City



PROJECT TITLE: REPAIR/ RENOVATION/ EXTENSION/ CONSTRUCTION/ UPGRADING/ IMPROVEMENT OF HEALTH FACILITIES FOR DON MANUEL LOPEZ MEMORIAL DISTRICT HOSPITAL LOCATION : BALAYAN, BATANGAS	PREPARED BY: JOHN LERY M. PALINES, CE ENGINEER II	CHECKED BY: ERIC JOSE R. MIRAS, RLA ARCHITECT III	REVIEWED BY: RONALD L. DOROTEO, CE ENGINEER III / PMU HEAD	APPROVED BY: EDUARDO C. JANAIRÓ, MD, MPH, CESO III DIRECTOR IV RACEL G. CARREON, MM CHIEF ADMINISTRATIVE OFFICER	SHEET CONTENT: ELEVATIONS SECTIONS	SHEET NUMBER: A-04
-----------------------------------------------------------------------------------------------------------------------------------------------------------------------------------------------------	-------------------------------------------------------------	-------------------------------------------------------------	----------------------------------------------------------------------	----------------------------------------------------------------------------------------------------------------------------------	------------------------------------------	-----------------------



1 FRONT ELEVATION
A-03 SCALE NTS.

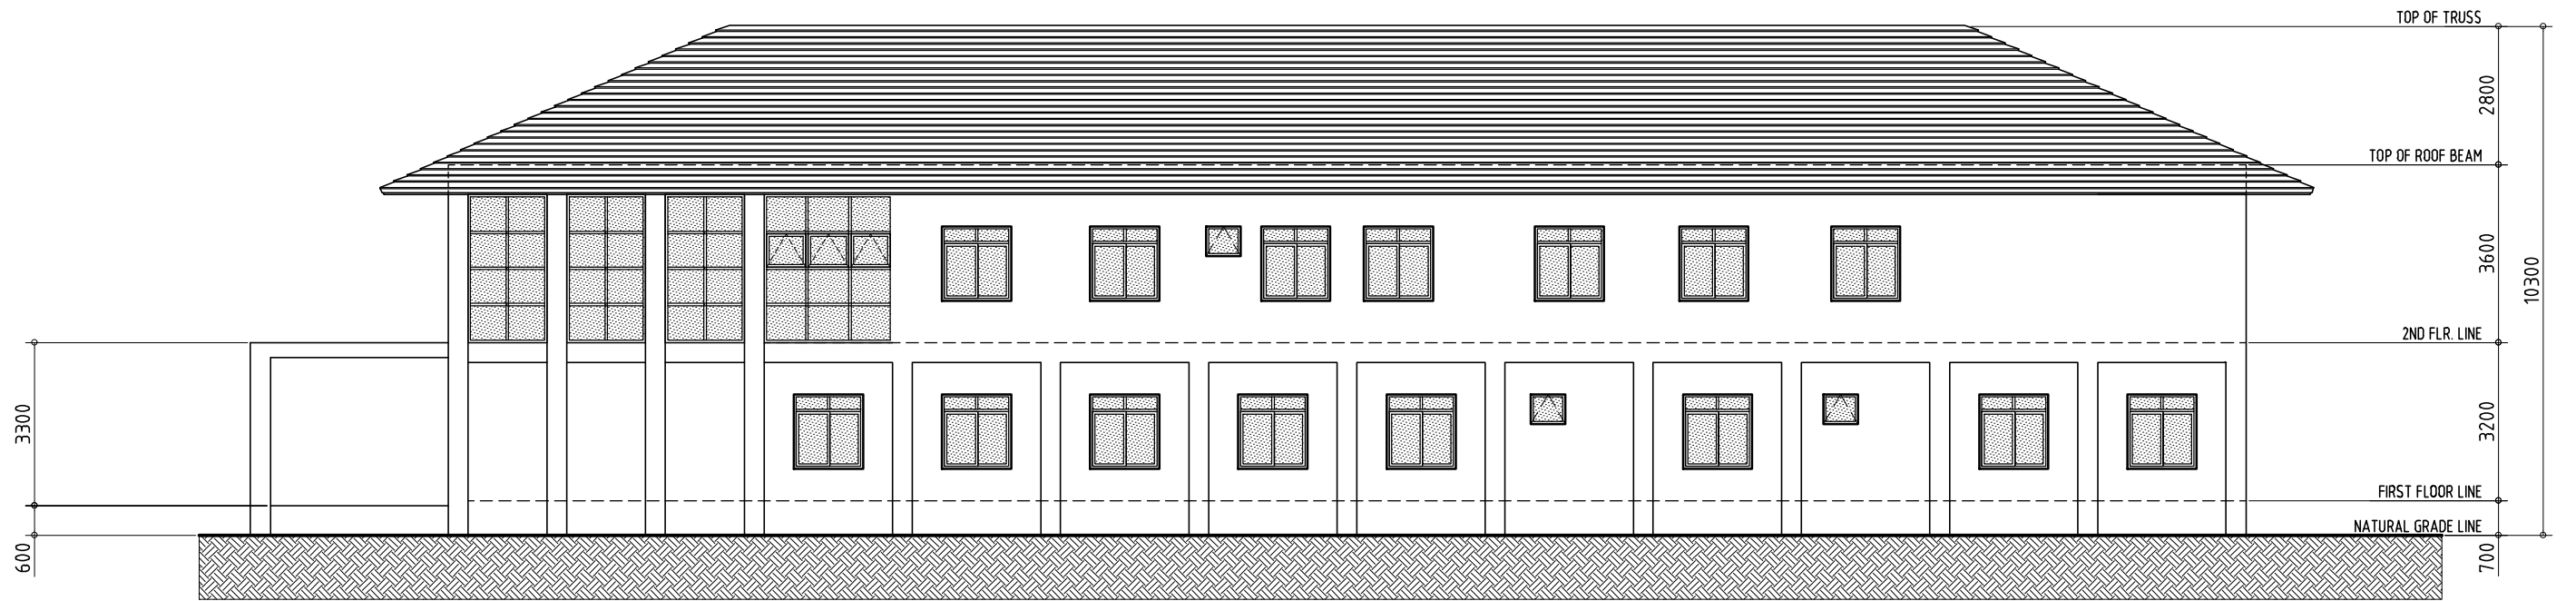


2 REAR ELEVATION
A-03 SCALE NTS.



Republic of the Philippines
DEPARTMENT OF HEALTH
Center for Health Development IV-A
CALABARZON
DOH-4A, QMMC Compound, Project 4, Quezon City



PROJECT TITLE:	PREPARED BY:	CHECKED BY:	REVIEWED BY:	APPROVED BY:	SHEET CONTENT:	SHEET NUMBER:
REPAIR/ RENOVATION/ EXTENSION/ CONSTRUCTION/ UPGRADING/ IMPROVEMENT OF HEALTH FACILITIES FOR DON MANUEL LOPEZ MEMORIAL DISTRICT HOSPITAL	JOHN LERY M. PALINES, CE ENGINEER II	ERIC JOSE R. MIRAS, RLA ARCHITECT III	RONALD L. DOROTEO, CE ENGINEER III / PMU HEAD	EDUARDO C. JANAIRI, MD, MPH, CESO III DIRECTOR IV RACEL G. CARREON, MM CHIEF ADMINISTRATIVE OFFICER PAULA PAZ M. SYDIONGCO, MD MPH, CESO IV ASSISTANT REGIONAL DIRECTOR	ELEVATIONS	A-03
LOCATION : BALAYAN, BATANGAS						

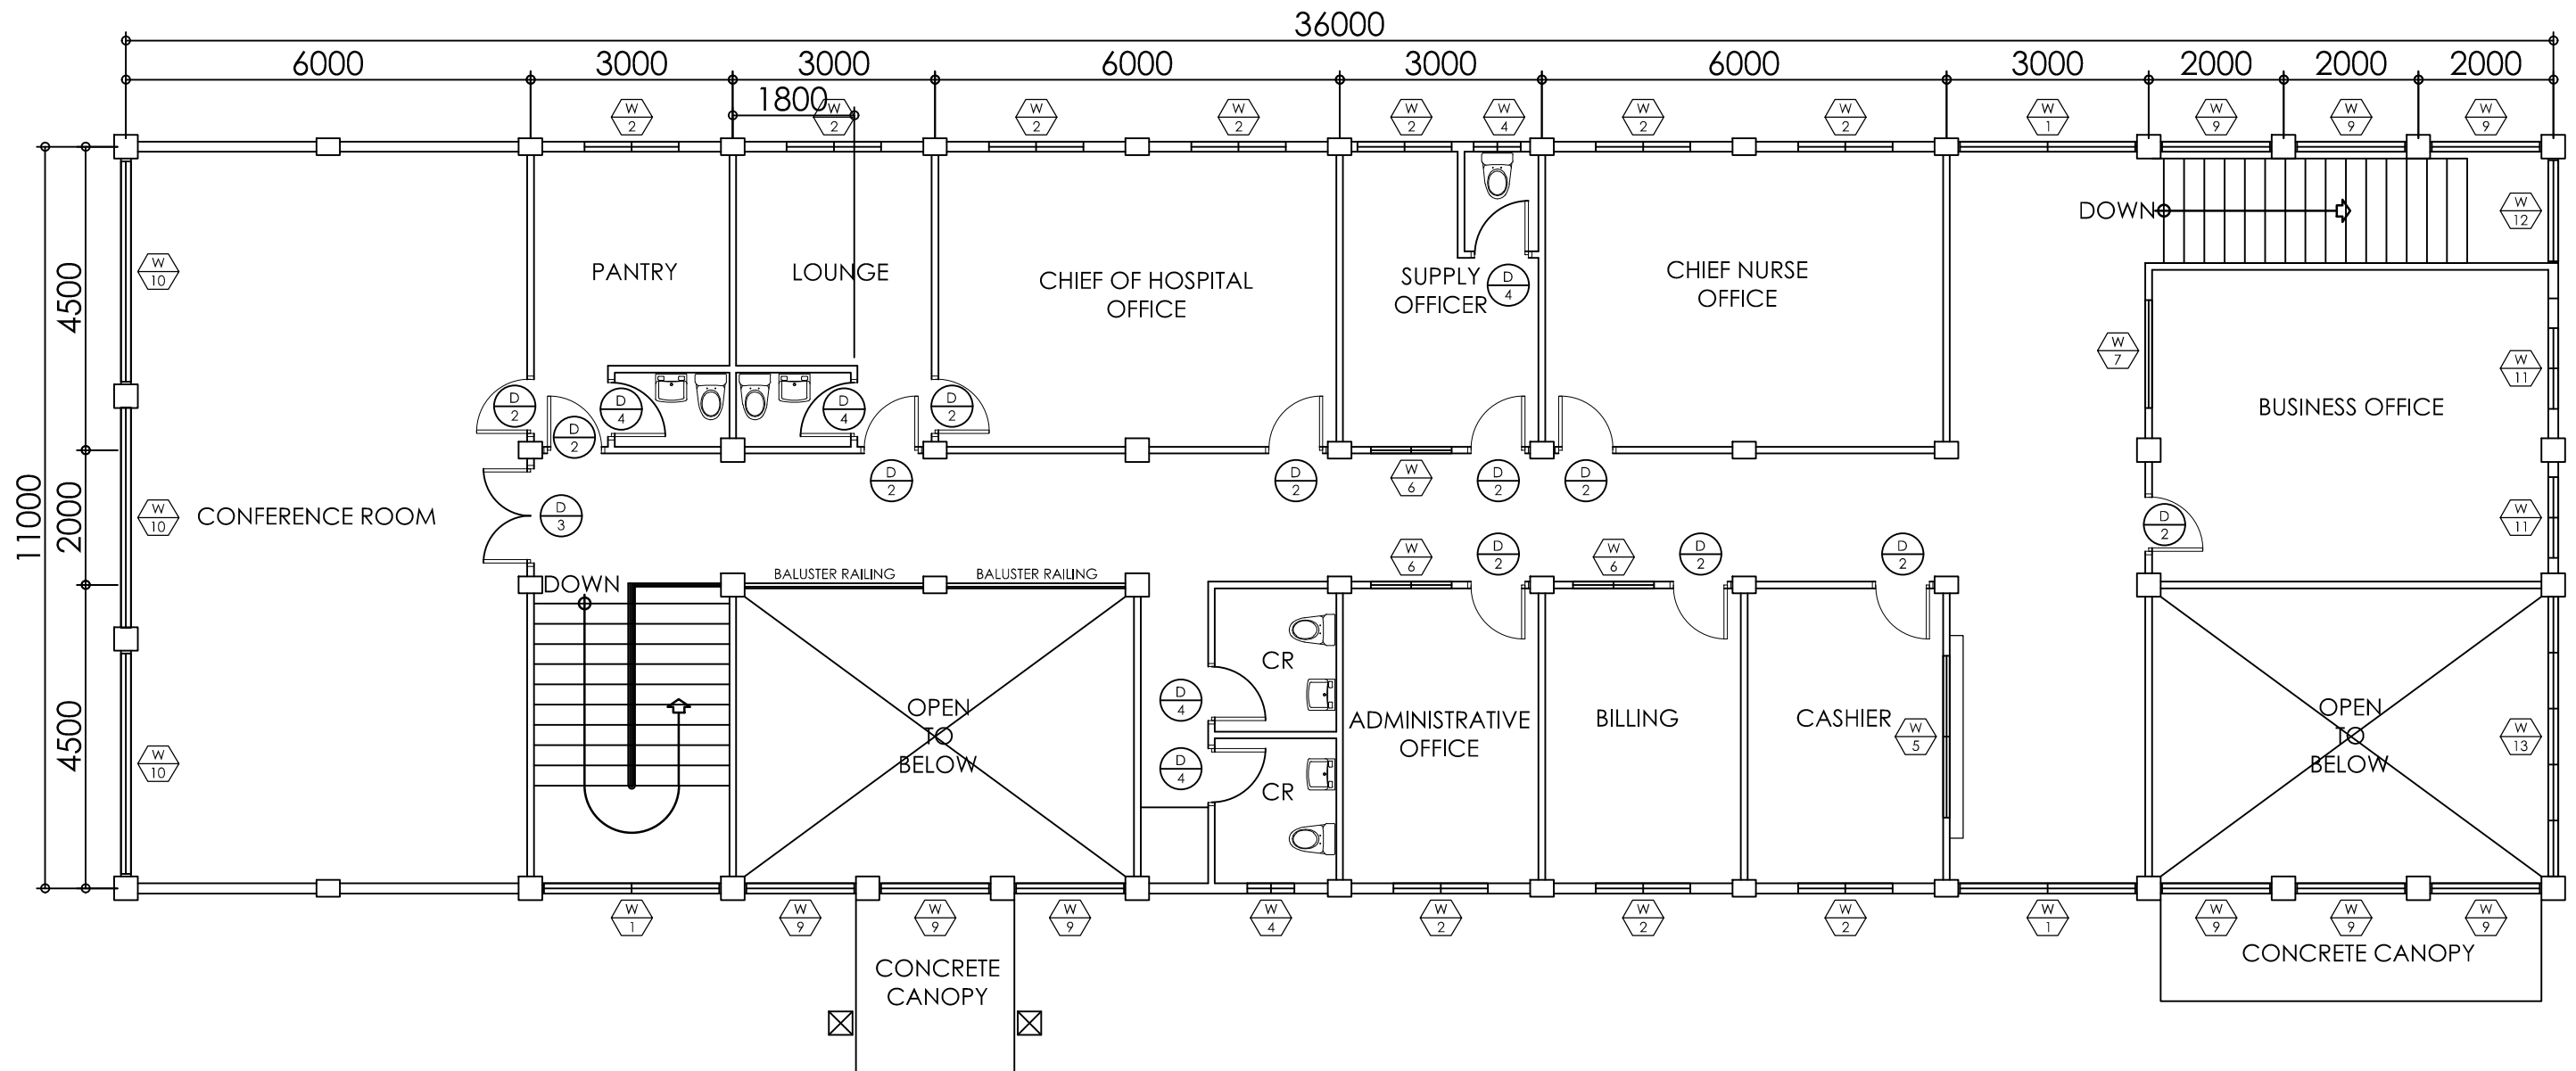

1 SECOND FLOOR PLAN
A-02 SCALE 1:100 mts.



Republic of the Philippines
DEPARTMENT OF HEALTH
Center for Health Development IV-A
CALABARZON
DOH-4A, QMMC Compound, Project 4, Quezon City



PROJECT TITLE:	PREPARED BY:	CHECKED BY:	REVIEWED BY:	APPROVED BY:	SHEET CONTENT:	SHEET NUMBER:
REPAIR/ RENOVATION/ EXTENSION/ CONSTRUCTION/ UPGRADING/ IMPROVEMENT OF HEALTH FACILITIES FOR DON MANUEL LOPEZ MEMORIAL DISTRICT HOSPITAL	JOHN LERY M. PALINES, CE ENGINEER II	ERIC JOSE R. MIRAS, RLA ARCHITECT III	RONALD L. DOROTEO, CE ENGINEER III / PMU HEAD	EDUARDO C. JANAIRO, MD, MPH, CESO III DIRECTOR IV RACEL G. CARREON, MM CHIEF ADMINISTRATIVE OFFICER PAULA PAZ M. SYDIONGCO, MD MPH, CESO IV ASSISTANT REGIONAL DIRECTOR	SECOND FLOOR PLAN	A-02
LOCATION : BALAYAN, BATANGAS						