



Republic of the Philippines  
Department of Health  
**CENTER FOR HEALTH DEVELOPMENT**  
**CaLaBaRzon**  
QMMC Compound, Project 4, Quezon City 1109  
Telephone Nos. 8-249-2000  
Email Add: bacsec.doh4a@gmail.com  
**BIDS AND AWARDS COMMITTEE**



## Request for Quotation

(NEGOTIATED PROCUREMENT UNDER **EMERGENCY CASES**)

**RFQ 007-2020**

**(SUPPLY AND INSTALLATION OF ELEVATED WATER TANK (1000GALLONS) FOR MALAININ ISOLATION BUILDING)**

The Department of Health – CENTER FOR HEALTH DEVELOPMENT IV-A (CALABARZON) through its **Bids and Awards Committee (BAC)**, invites PhilGEPS Registered Contractors to submit its **SEALED QUOTATION** or send thru email at [bacsec.doh4a@gmail.com](mailto:bacsec.doh4a@gmail.com) for the following items on or before **August 10, 2020; 10:00 AM** at the 3<sup>rd</sup> floor Conference Room, Center for Health Development IV-A, QMMC Compound, Project 4, Quezon City.

Copies of the eligibility, technical and financial documents are also required to be submitted along with the quotation/proposal. (Please see attached Checklist of Requirements)

For clarification, you may contact the BAC Secretariat at (02) 8-249-2000.

**NOEL G. PASION, MD, MPH, CESE**  
BAC Chairperson

Date: \_\_\_\_\_

**NOEL G. PASION, MD, MPH, CESE**

BAC Chairperson

DOH Center for Health Development CALABARZON

QMMC Compound, Project 4, Quezon City

Sir:

After having carefully read and accepted the terms and conditions in the Request for Quotation, hereunder is our quotation/s for the item/s as follow:

Item No.	Unit of Measure	ITEM AND DESCRIPTION	QTY	TOTAL ABC	(Please specify Origin/Brand/ Model)	UNIT PRICE	TOTAL PRICE
1	lot	Elevated Water Tank with Labor	1	500,000.00			
		>>> nothing follows<<<					
		Total:		P500,000.00			

The above-quoted price/s are inclusive of all costs and applicable taxes.

\_\_\_\_\_  
Name & Signature of Representative

\_\_\_\_\_  
Name of Company

\_\_\_\_\_  
Contact Number

DOH4A-BAC-RFQ-NEGO-Rev0





Republic of the Philippines  
Department of Health  
Center for Health Development IV-A CALABARZON  
**BIDS AND AWARDS COMMITTEE**  
QMMC Compound, Project 4, Quezon City  
Tel.: 440-3551/440-3372



### REQUEST FOR QUOTATION

August 3, 2020

The Department of Health Center for Health Development IV-A through the Bids and Awards Committee (BAC), invites **all eligible contractors** to submit a **Sealed Quotation** for the following projects for open negotiation to select the **best and final offer** on or before **August 10, 2020 10:00am** at the 3<sup>rd</sup> Floor Conference Room, Center for Health Development IV-A, QMMC Compound, Project 4, Quezon City or email at **bacsec.doh4a@gmail.com**

RFQ No.	Name of Projects	Location	Approved Budget of the Contract	Calendar Days
RFQ No. 2020-E-025-A	Installation of Insecticide Treated Screen Net for Malainin Isolation Facility	Brgy. Malainin, Ibaan, Batangas	P58,200.00	15 CDs
	Installation of Dry Wall Partition for Malainin Isolation Facility		P91,890.00	
		<b>TOTAL:</b>	<b>P150,090.00</b>	
RFQ No. 004-2020-A	Construction of Wash Area and Shower Room at Swabbing Testing Area	DOH – CHD Calabarzon	P180,000.00	30 CDs
RFQ No. 005-2020-A	Proposed Receiving Counter with Protective Shield, DOH CHD4A	DOH – CHD Calabarzon	P42,000.00	15 CDs
RFQ No. 006-2020	Installation of Acrylic Partition at Second Floor Admin Building	DOH-CHD CaLaBaRZon	P381,635.52	15 CDs
RFQ No. 007-2020	Supply and Installation of Elevated Water Tank (1000Gallons) for Malainin Isolation Building	Brgy. Malainin, Ibaan, Batangas	P500,000.00	15 CDs

Please see attached Checklist of Requirements

For clarification, you may contact the BAC Secretariat at 8249-2000 local 4411.

**NOEL G. PASION, MD, MPH, CESE**  
Chairperson, Bids and Awards Committee



Republic of the Philippines  
**Department of Health**  
**CENTER FOR HEALTH DEVELOPMENT**  
**CaLaBaRZon**  
QMMC Compound, Project 4, Quezon City 1109  
Telephone Nos. 8-249-2000  
Email Add: bacsec.doh4a@gmail.com  
**BIDS AND AWARDS COMMITTEE**




***CHECKLIST OF REQUIREMENTS***  
**(NEGOTIATED PROCUREMENT UNDER EMERGENCY CASES)**

**Name of Company:** \_\_\_\_\_

- ☐ 1. PCAB License (Cat. "C" & "D" Small B or higher)
- ☐ 2. Mayor's Permit (2020)
- ☐ 3. PhilGEPS Registration Certificate (Platinum)
- ☐ 4. Omnibus Sworn Statement (notarized)
- ☐ 5. Income Tax Return of preceding tax year OR Business Tax Returns (Value Added Tax or Percentage Tax Return covering the previous six (6) months.
- ☐ 6. Company Profile
- ☐ 7. Detailed Estimate and Program of Works
- ☐ 8. Net Financial Contracting Capacity (NFCC) if ABC is above P500,000.00
- ☐ 9. Bid Form


**Checked by:**

BIDS AND AWARDS COMMITTEE							DATE

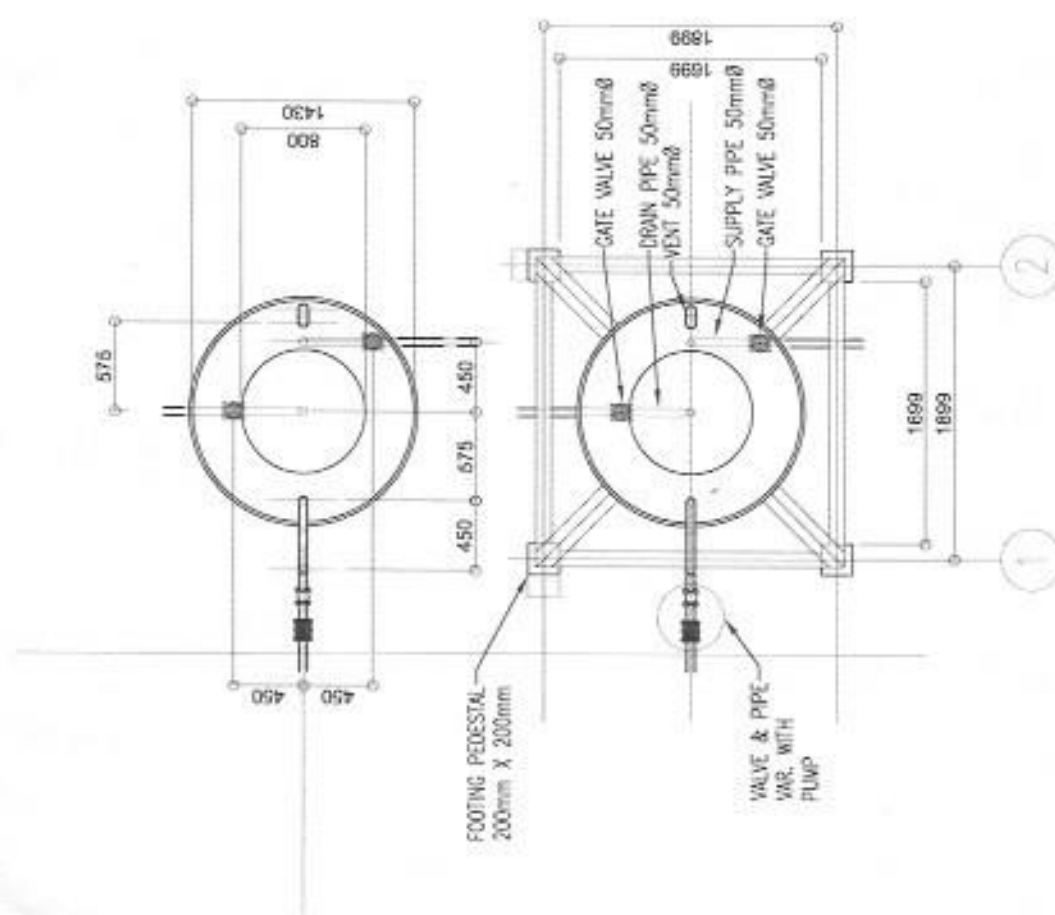

ELEVATED TANK  
TOP VIEW

1 7 SCALE 1 : 50 METERS

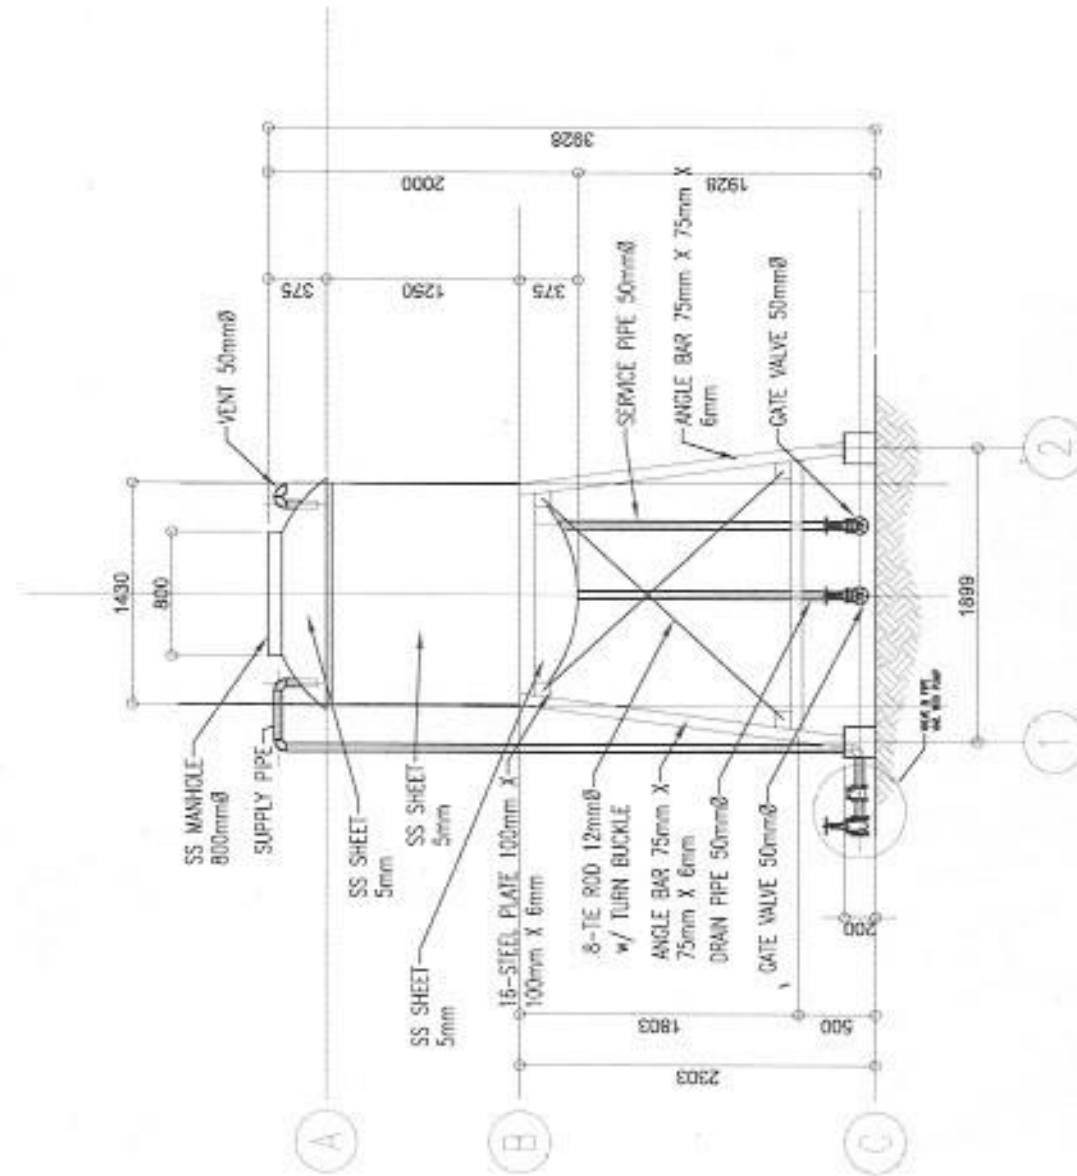


ELEVATED TANK  
ELEVATION PLAN

2 7 SCALE 1 : 50 METERS

NOTE: PLEASE VERIFY ACTUAL DIMENSIONS ON SITE

DRAWN BY:	APPROVED BY:	REVIEWED BY:	CHECKED BY:	PREPARED BY:	PROJECT TITLE:	LOCATION:	SHEET NUMBER:
	EDUARDO C. BENAVIDES, MD, MPH, CESO II DIRECTOR IV	RONALD L. DOROTERO, CE ENGINEER III (PMU-HEO)	G. FRILLIES PML DRAFTSMAN	REHABILITATION/IMPROVEMENT OF MALAININ ISOLATION FACILITY	BRGY. MALAININ, BAYAN BATANGAS CITY	A7	ELEVATED TANK TOP VIEW ELEVATED TANK ELEVATION PLAN
	PAULA PAZ M. TYDIONCO, MD, MPH, CESO II ASSISTANT REGIONAL DIRECTOR						



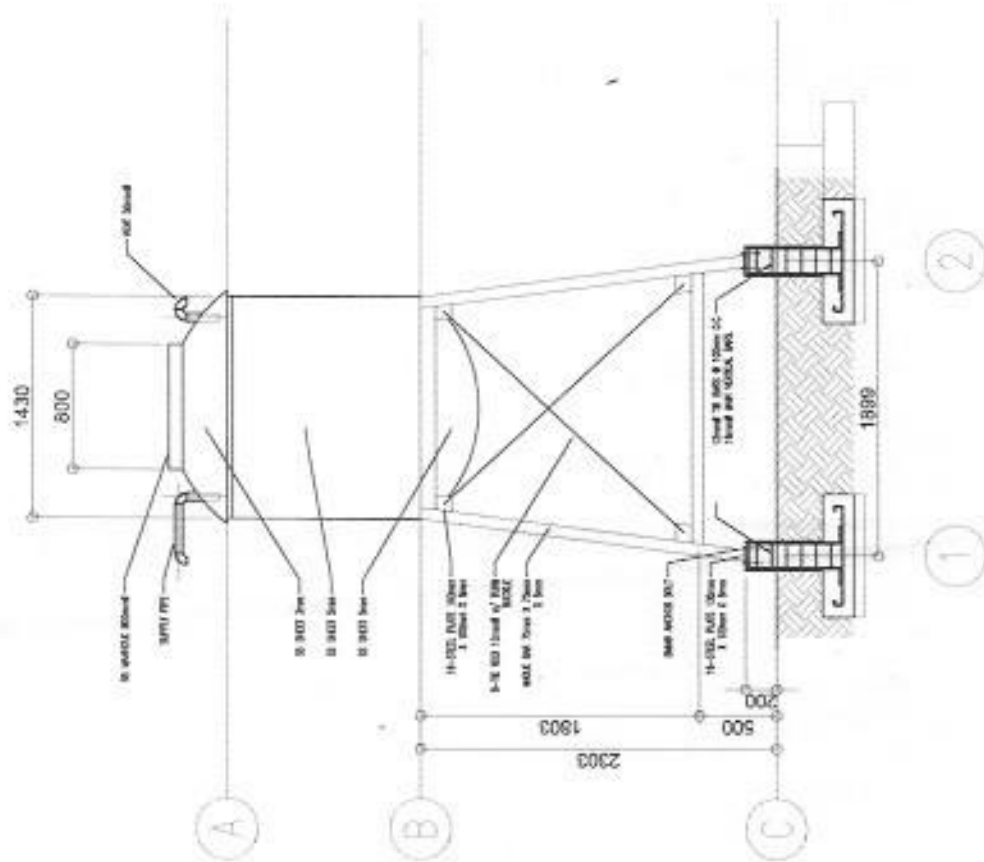

FOUNDATION PLAN  
1 : 50 METERS

NOTE: PLEASE VERIFY ACTUAL DIMENSIONS ON SITE



Republic of the Philippines  
DEPARTMENT OF HEALTH  
Center for Health Development (V.A.)  
CNS/HR/2016  
DOH-AN, QMC Compound, Project 8, Quezon City

PROJECT TITLE  
REHABILITATION/IMPROVEMENT OF  
MALAININ ISOLATION FACILITY

PREPARED BY  
J. P. FELLES  
P.E. 014772899

CHECKED BY  
J. P. FELLES  
P.E. 014772899


REVIEWED BY  
RONALD L. BOROTED, CE  
ENGINEER III / PM / HEAD

APPROVED BY  
EDUARDO C. LONARDO, MD, MPH, CESO II  
DIRECTOR IV  
J. P. FELLES, MD, MPH, CESO IV  
ASSISTANT HOSPITAL DIRECTOR

SHEET CONTENT  
FOUNDATION PLAN

SHEET NUMBER  
S1

CONCURRED BY:

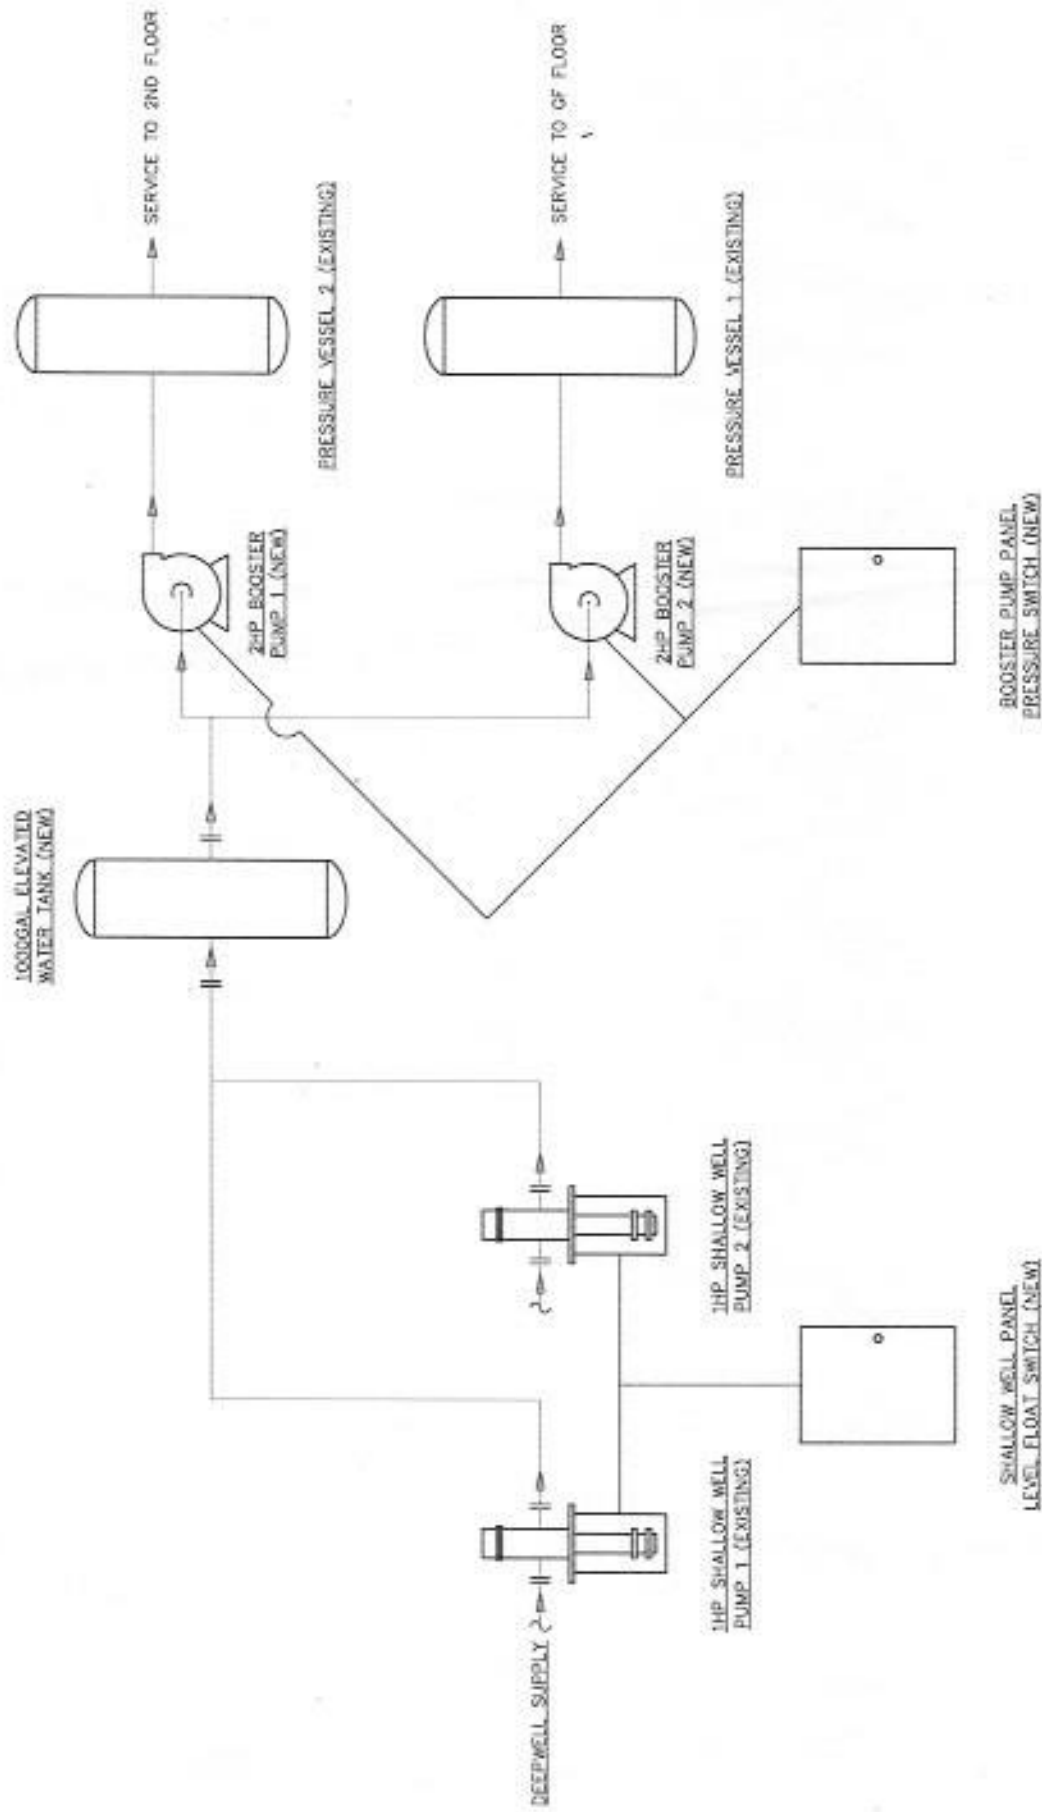

# PIPING DIAGRAM

SCALE

NOTE: PLEASE VERIFY ACTUAL DIMENSIONS ON SITE



Republic of the Philippines  
DEPARTMENT OF HEALTH  
Office of the Regional Director  
Cebu City



PROJECT TITLE  
REHABILITATION/IMPROVEMENT OF  
MALAMIN ISOLATION FACILITY  
LOCATION: BRGY MALAMINUBAAN, BATANGAS CITY

PREPARED BY  
G. FRILLES  
(H) DRAFTSMAN

CHECKED BY  
R. L. BORCERO, CE  
ENGINEER II (PL) HEAD

REVIEWED BY  
EDUARDO J. JANA, MD, MPH, CESO III  
DIRECTOR IV  
RACER, G. ARREDON, MN  
SALES & SERVICE  
PHILIPPINE MEDICAL SUPPLY, INC.

APPROVED BY  
EDUARDO J. JANA, MD, MPH, CESO III  
DIRECTOR IV  
RACER, G. ARREDON, MN  
SALES & SERVICE  
PHILIPPINE MEDICAL SUPPLY, INC.

SHEET CONTENT  
PIPING LAYOUT

SHEET NUMBER  
P1